

C:\Users\pba\Documents\Drawings\Plan_Facility\00001_FloorPlan_001.dwg
DRAWN BY: ABA Checked By: CASH
12/20/2016 10:41:16 AM


FLOOR PLAN NOTES	
1	DO NOT SCALE FROM THE DRAWINGS. CONTRACTOR SHALL REQUEST FROM THE ARCHITECT FOR ANY DIMENSIONS NOT SHOWN ON THE DRAWINGS.
2	GRID LINES SHOWN ARE LOCATED AT CENTERLINE OF COLUMNS U.O.N.

1
10" = 1'-0"

OVERALL FLOOR PLAN

GRAPHIC LEGEND

- Existing Hydraulic Line
- Existing ATF Line
- Existing Antifreeze Line
- Existing Engine Oil Line
- EXISTING AIR HOSE REEL
- EXISTING HOSE REEL
- NEW HOSE REEL

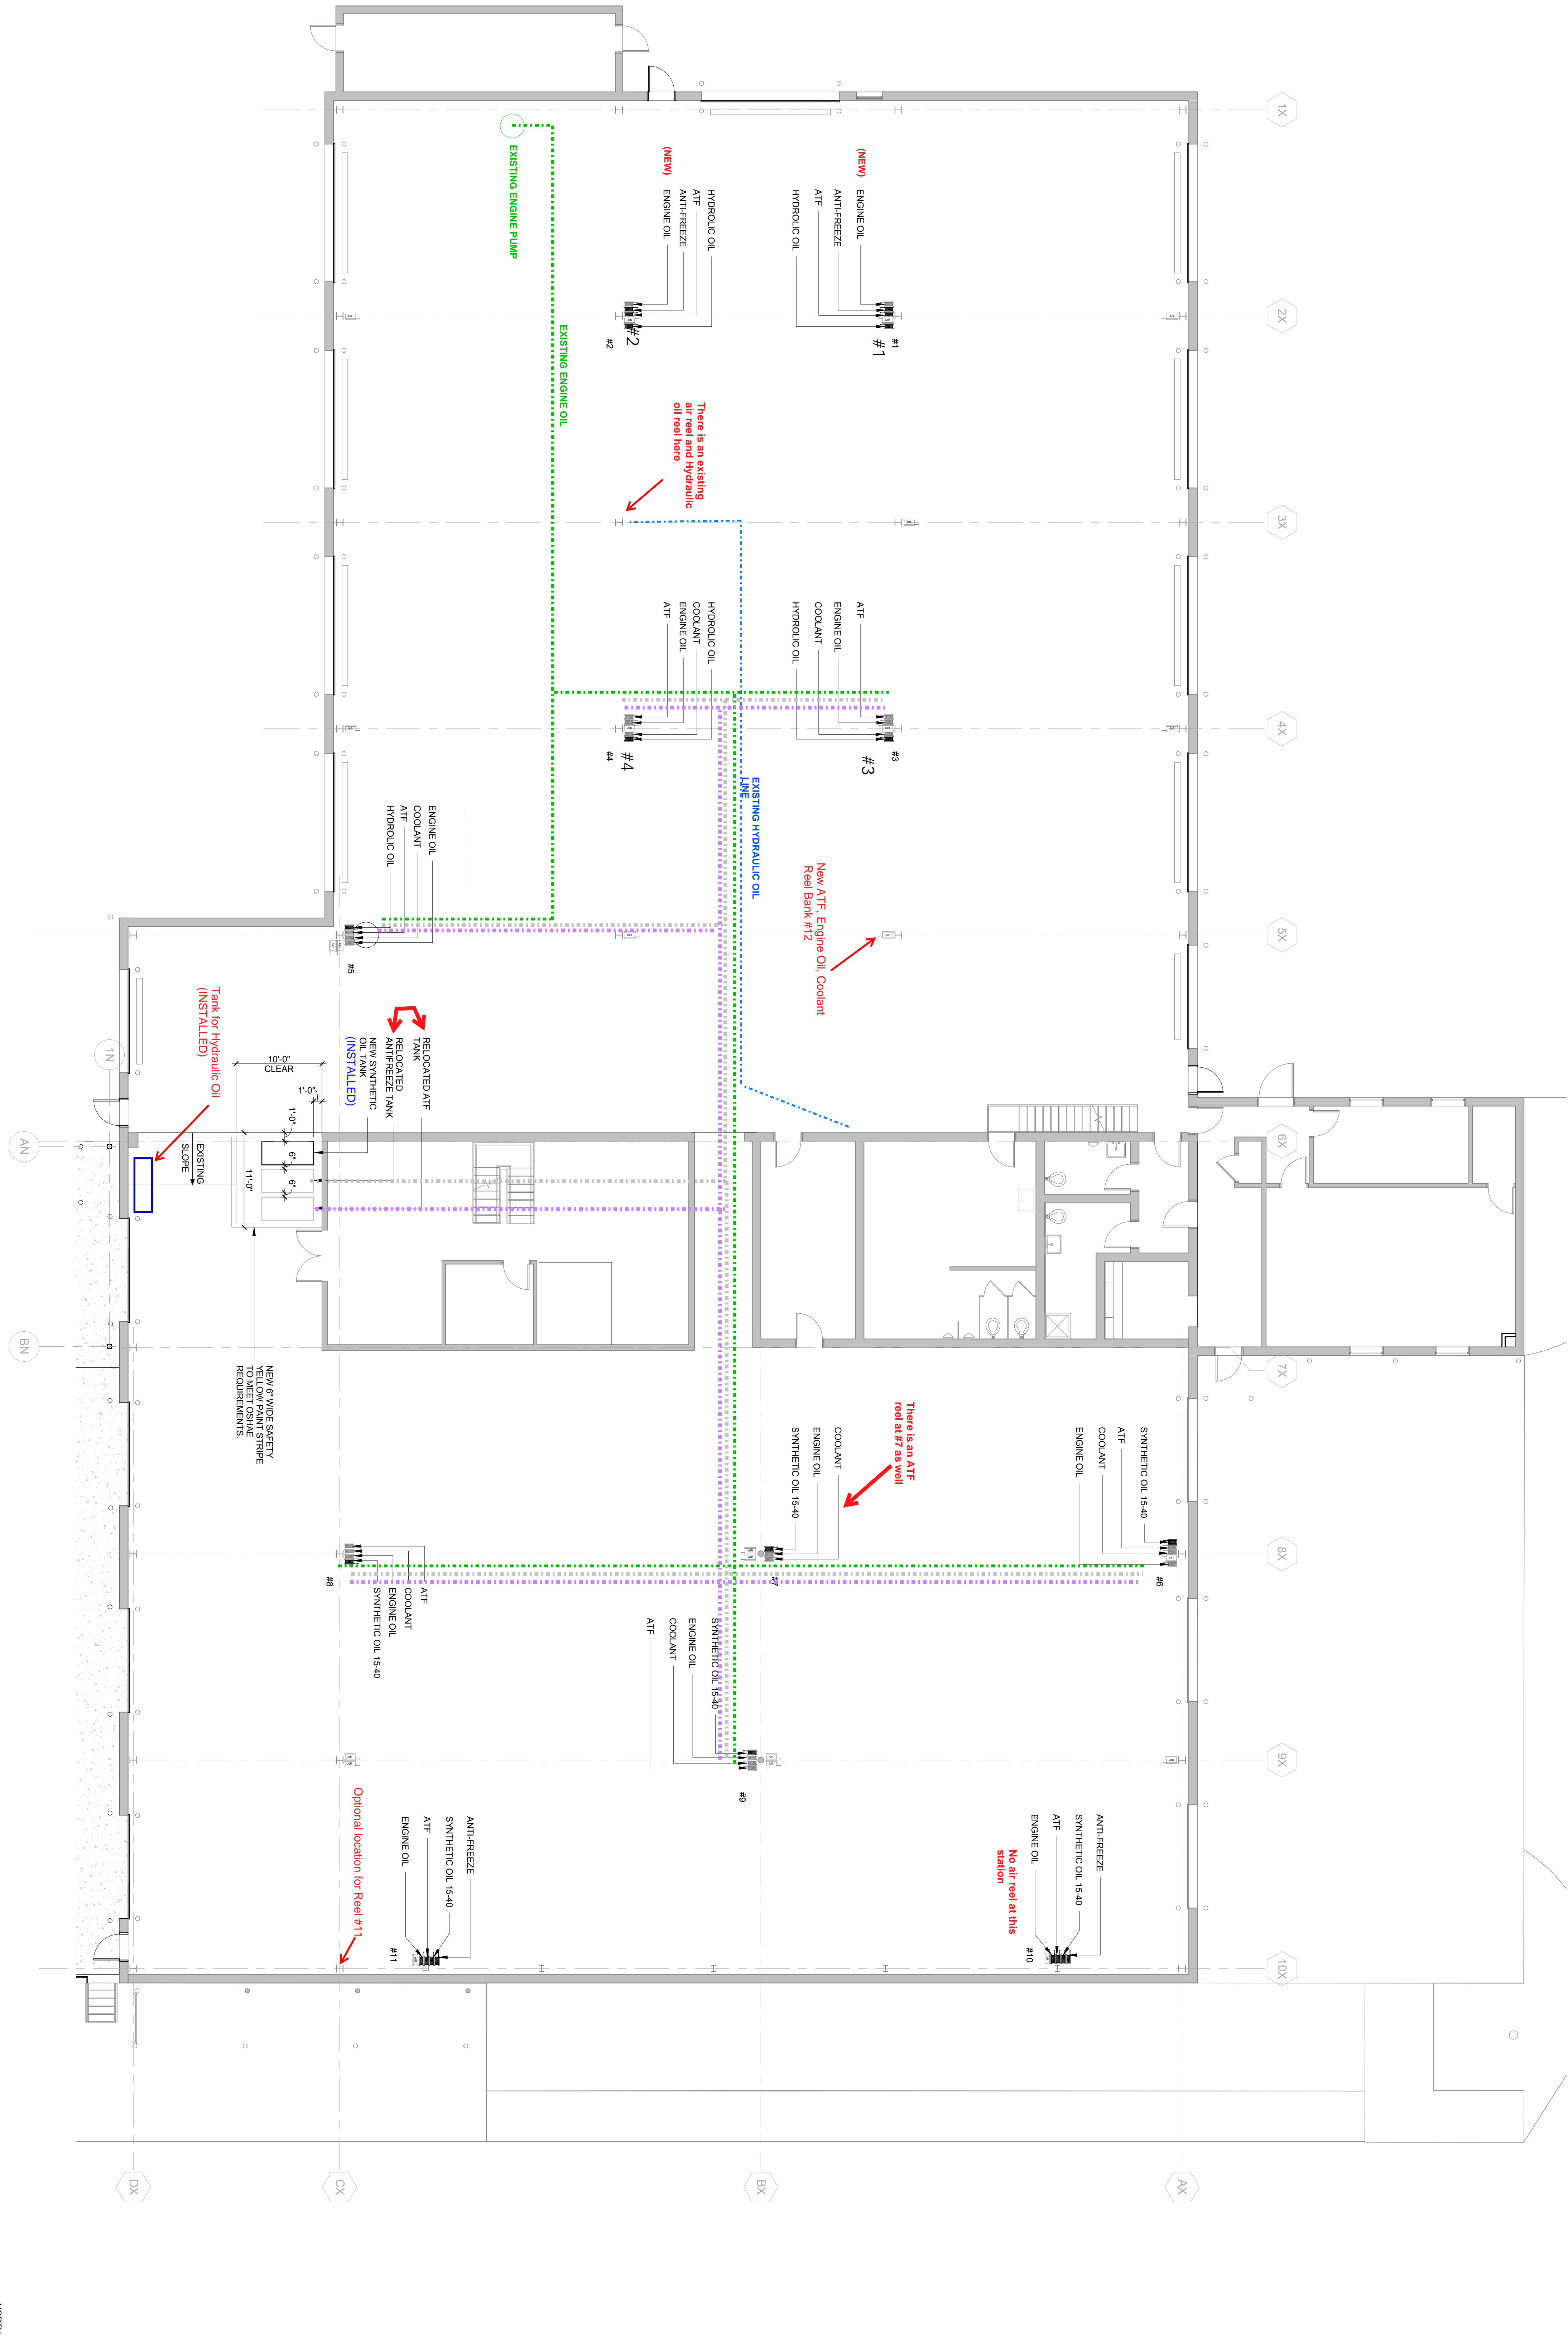

COUNTY OF FAIRFAX
ALBAN MAINTENANCE FACILITY
Project No. : 30010/ TF-000004-001A
Contract No. : CN17303103
7245 FULLERTON ROAD
SPRINGFIELD, VA 22150

ADTEK ENGINEERS - CIVIL
EHLERT BRYAN - STRUCTURAL
RNL - ARCHITECTURAL
MDG - EQUIPMENT DESIGN
S3E ENGINEERS, INC. - MEP & FP
GEOCONCEPTS ENGINEERING, INC. - GEOTECH
BRINJAC ENGINEERING - HVAC COMMISSIONING
DOWNEY & SCOTT, LLC - COST ESTIMATING



RNL
1600 WILSON BLVD.
SUITE 360
ARLINGTON, VA 22209
571 290 7679 t

1 LUBE SYSTEM & EYE WASH 10/31/2018
No. REVISION SUBMISSION DATE
PROJECT No. 404801
Project No. : 30010/ TF-000004-001A
FLOOR PLAN

A-103