


- R2 Auditorium
- R2-9 Barracks
- R3 Barber Shop, inmates.
- R3-15 Commissary
- R3-14 Officers Quarters
- R16 Bath House
- R16-1 Gymnasium/Gator/Alto Shop
- R17 Control Building
- R18 Post Office
- R19 Shop Building
- R20 Post Office Custody
- R21 Shop Building
- R22 Shop Building
- R23 Laundry Annex
- R24 Dormitory
- R24-1 Superintendent's Office
- R24-2 Superintendent's Office Annex
- R27 Mess Hall-Kitchen - Cold Storage
- R28 Heating Plant
- R29 Mess Hall - Eastern Shops
- R30 Laundry
- R30 Garage Office
- R30-3 Garage Shop
- R30-4 Cold Storage Shop
- R41 Chapel
- R41-1 Warehouse & Service Building
- R41-2 CWA Building
- R42 Plumbing & Electric Shops
- R40 Dispatch Office

H41 Resident Supt. Prof
H45 Supt of Industries
H46 Silverbrook Wood
H48 Foreman of Utilities
H51 Resident Physician
H52 Captain of Guard Regt.
H53 Supt of Chicken Ranch
H59 Educational Director
H60 General Supt.
H63 Supt of Orchard

P1 Industrial Bldg - Knitting-Tailor
P2 Cell Block A
P3 Industrial Bldg - Print & Broom
P4 Cell Block B
P5 Industrial Bldg - Shirt
P6 Cell Block C
P7 Visitor's Bldg
P12 Mess Hall
P15 Sallé Port & Main Gate
P16 Armory

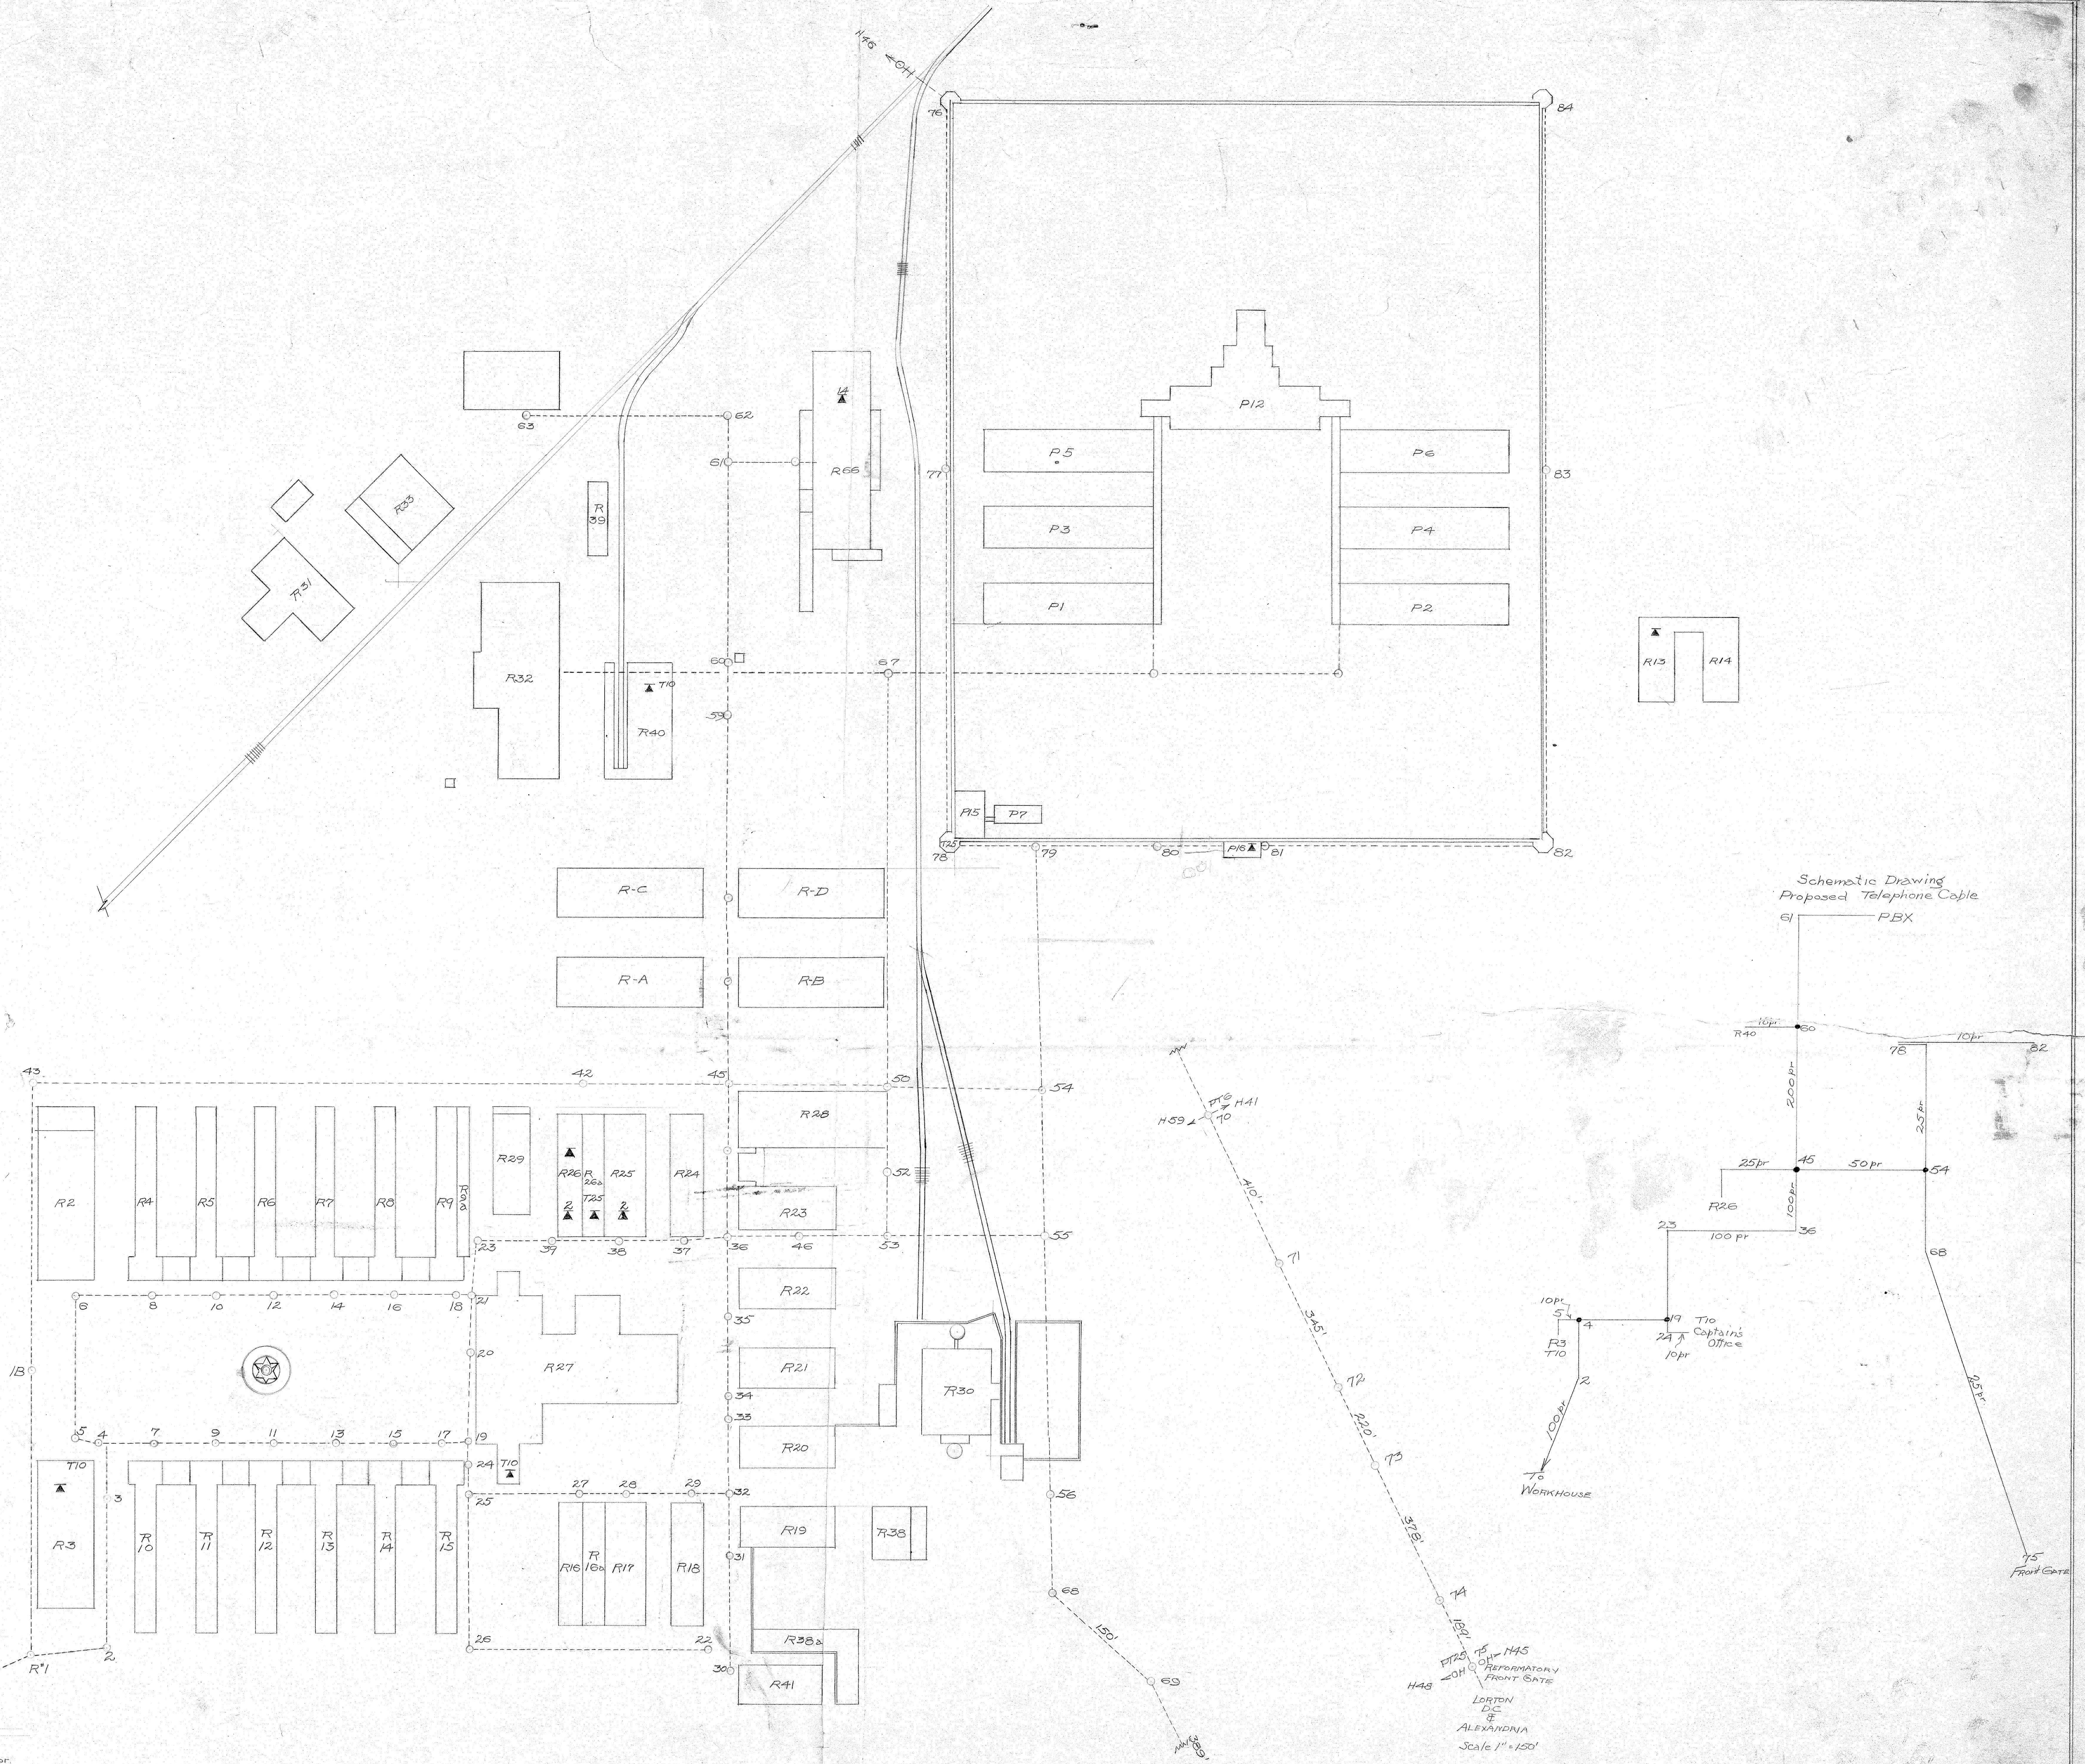

Ref Hole #1

Ref Hole #1

295'
300'
300'
83'
191'
273'
302'
129'
500'
300'
100'
231'
199'
16'
120'
429'
563'
100'
420'
256'
1090'

W. H. Hole 33-393

W.H. Hole 33-393

Residences
H51
H52
H53
H60
H63

WORKHOUSE
2 duct { 1-MTY
 { 1-100 pr

- ☒ Outside phones existing
- ☒ Outside phones prospective
- ☒ Outside phone on OH Line
- ☒ No. of outside phones in building

T6 - Terminal Spair

PTE - Protected Terminal Spair

SIGNAL DUCTS			
REFORMATORY & PENITENTIARY DIV.			
OFFICE # CONSTRUCTION ENGINEER		LORTON, VA	
SCALE 1"=6'		OCT. 1945	
DRAWN SEPT 10, 1945		CHECKED 9-20-45	
		TRACED 10-1-45	
		PROJECT	WORK ORDER
<i>Ed Heuser</i>	10-1-45 CHIEF ELECT		
<i>Walter Guide</i>	10-1-45 SHEET ENGINEER SHEET ASST. IN CHARGE GEN. Supt DIN & P. IN WFL	SHEET	FILE
		1 of 2	