

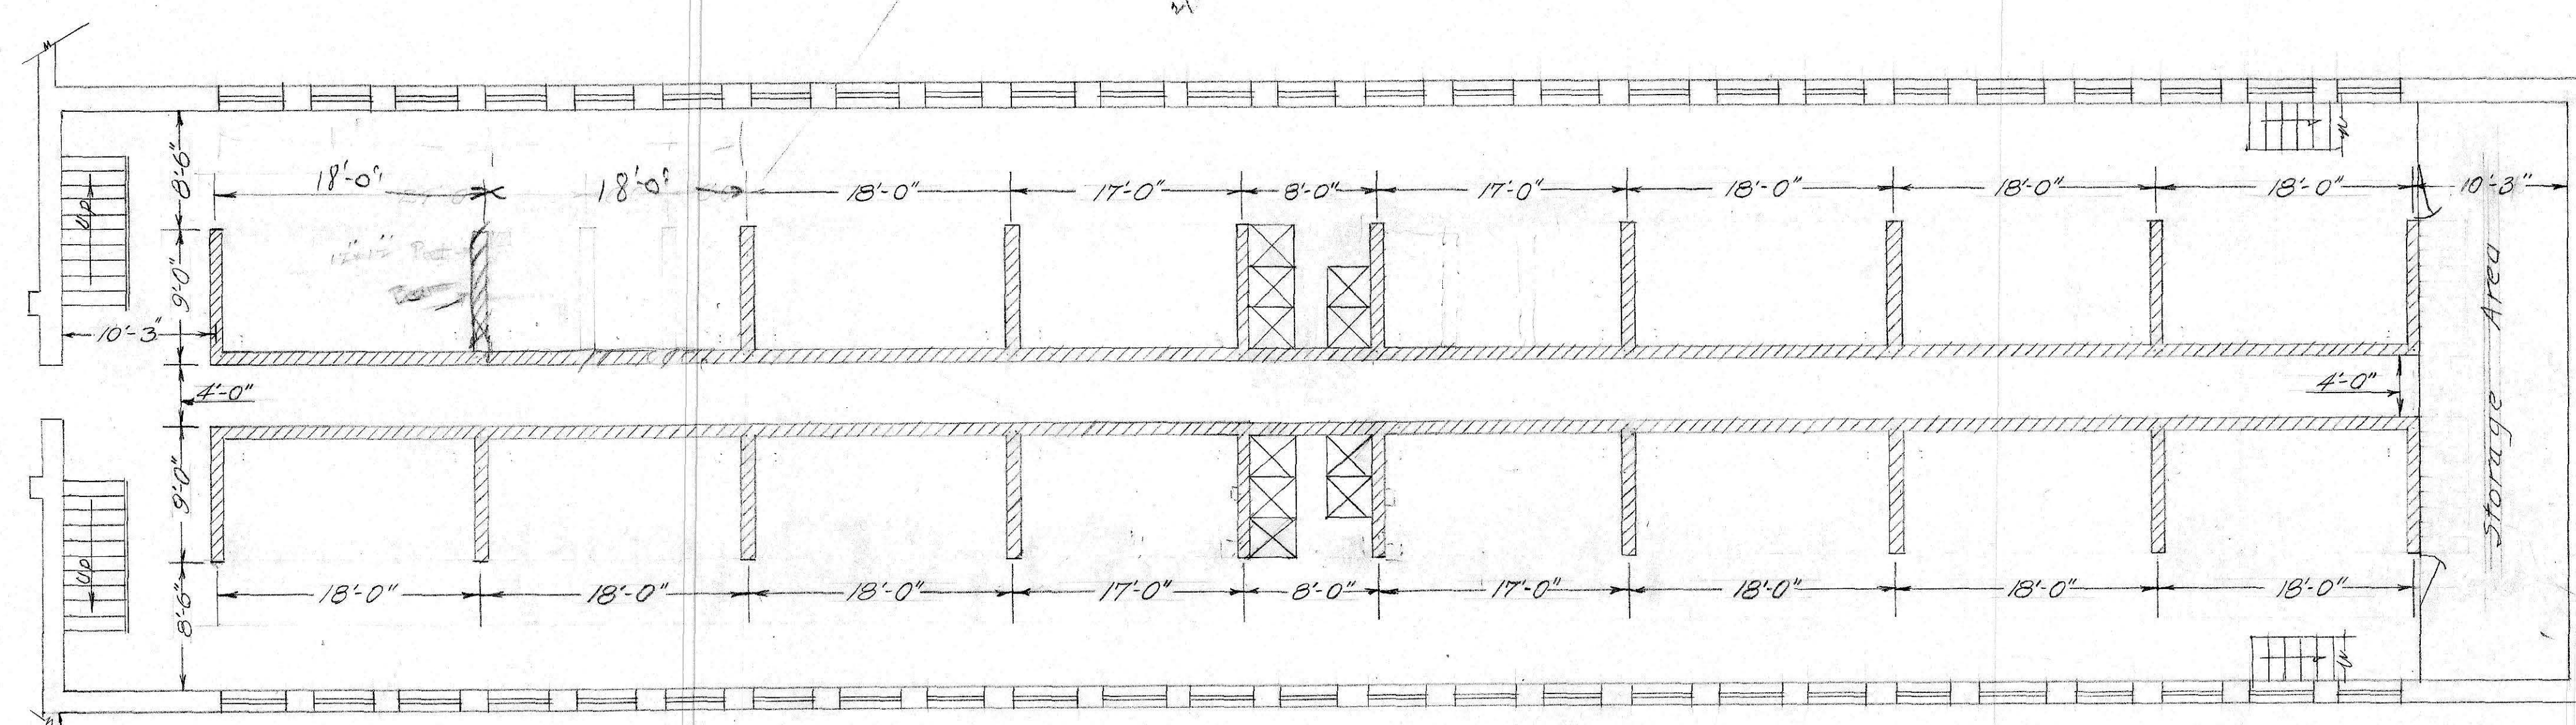


PLANS	DATE
CONST.	
ELEC.	
PLUMB.	

all 90 wall on both sides similar by PLM. 2/11/41

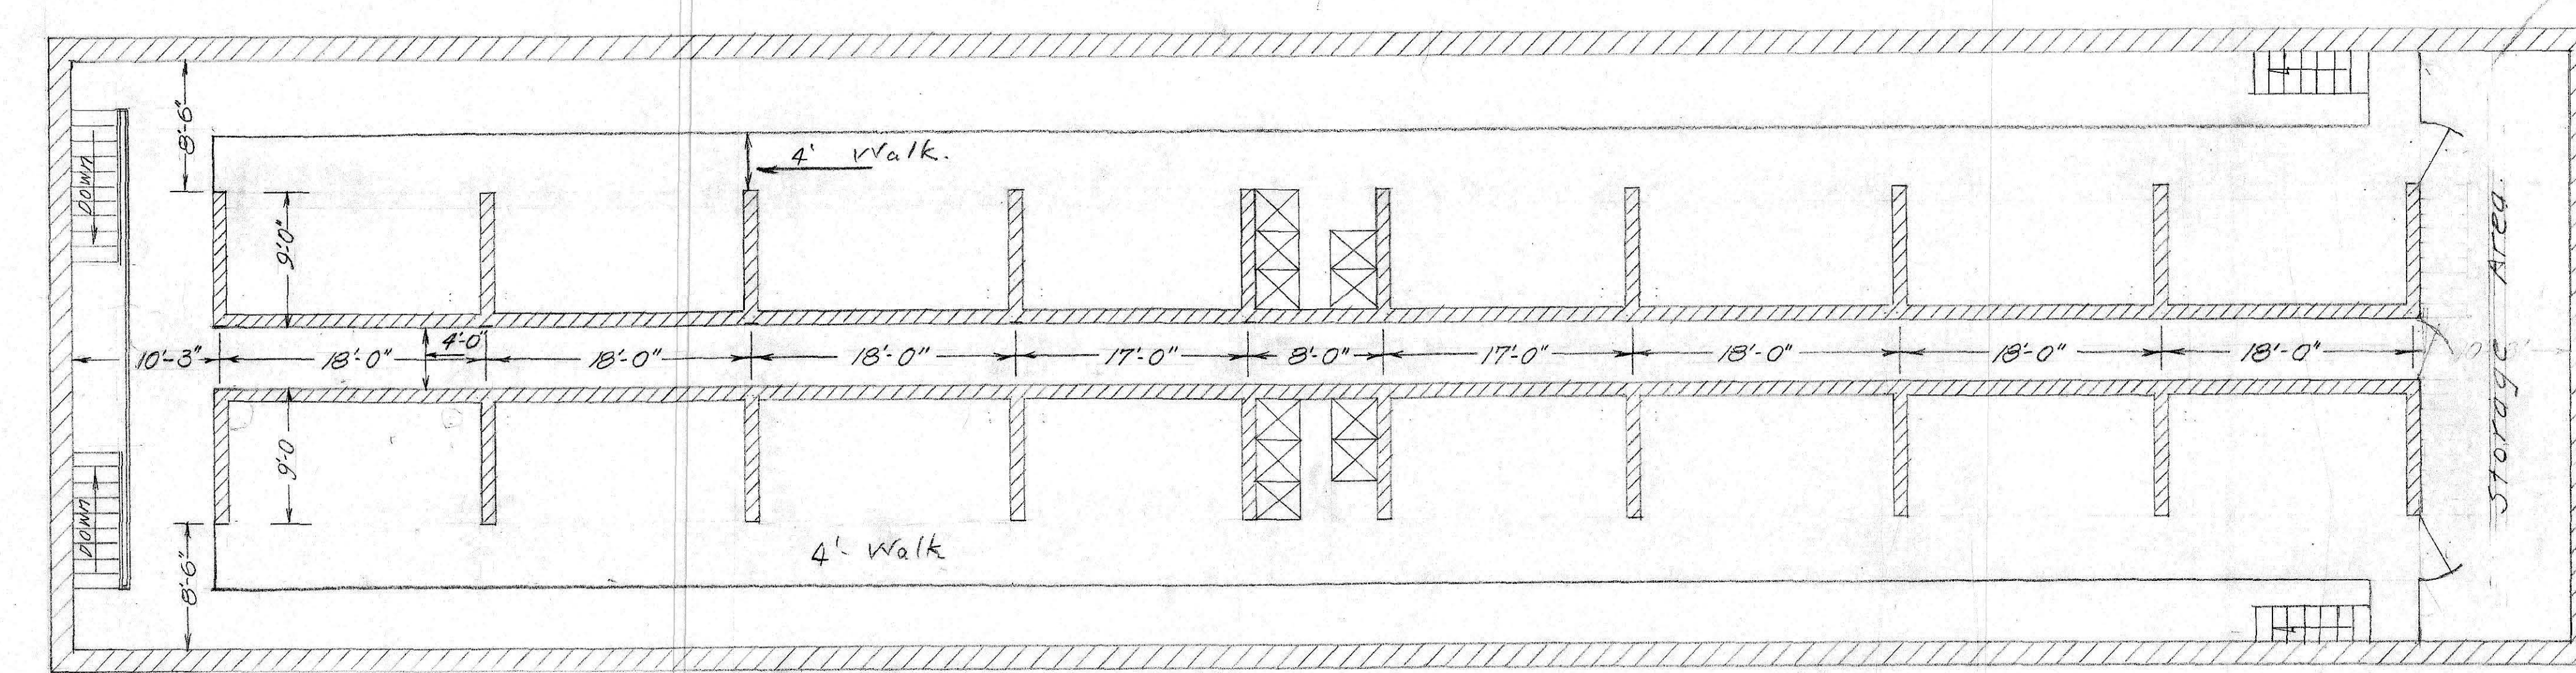

First Floor Plan

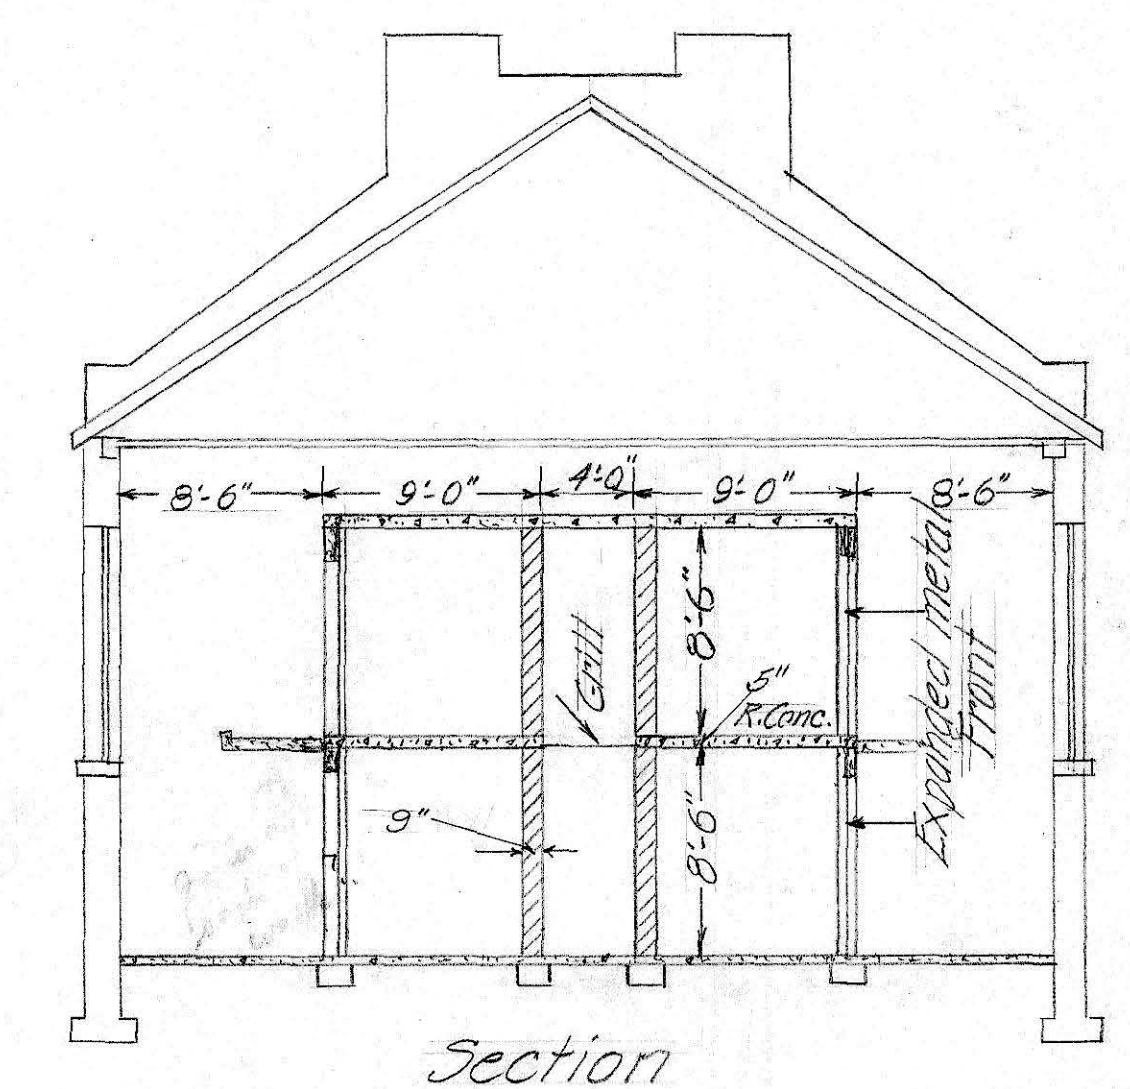

Second Floor Plan

90° door

Constructing Engineers Office			
D.C. Penal Institutions - Lorton, Va.			
Interior Walls For Cell Bldg.			
#6 Wall Group - Lorton, Va.			
Scale - 1/8" = 1'-0"			
Drawn by	Checked	Date	No.
Deming		1-2-41	8
1-OF 4			GZ-24