



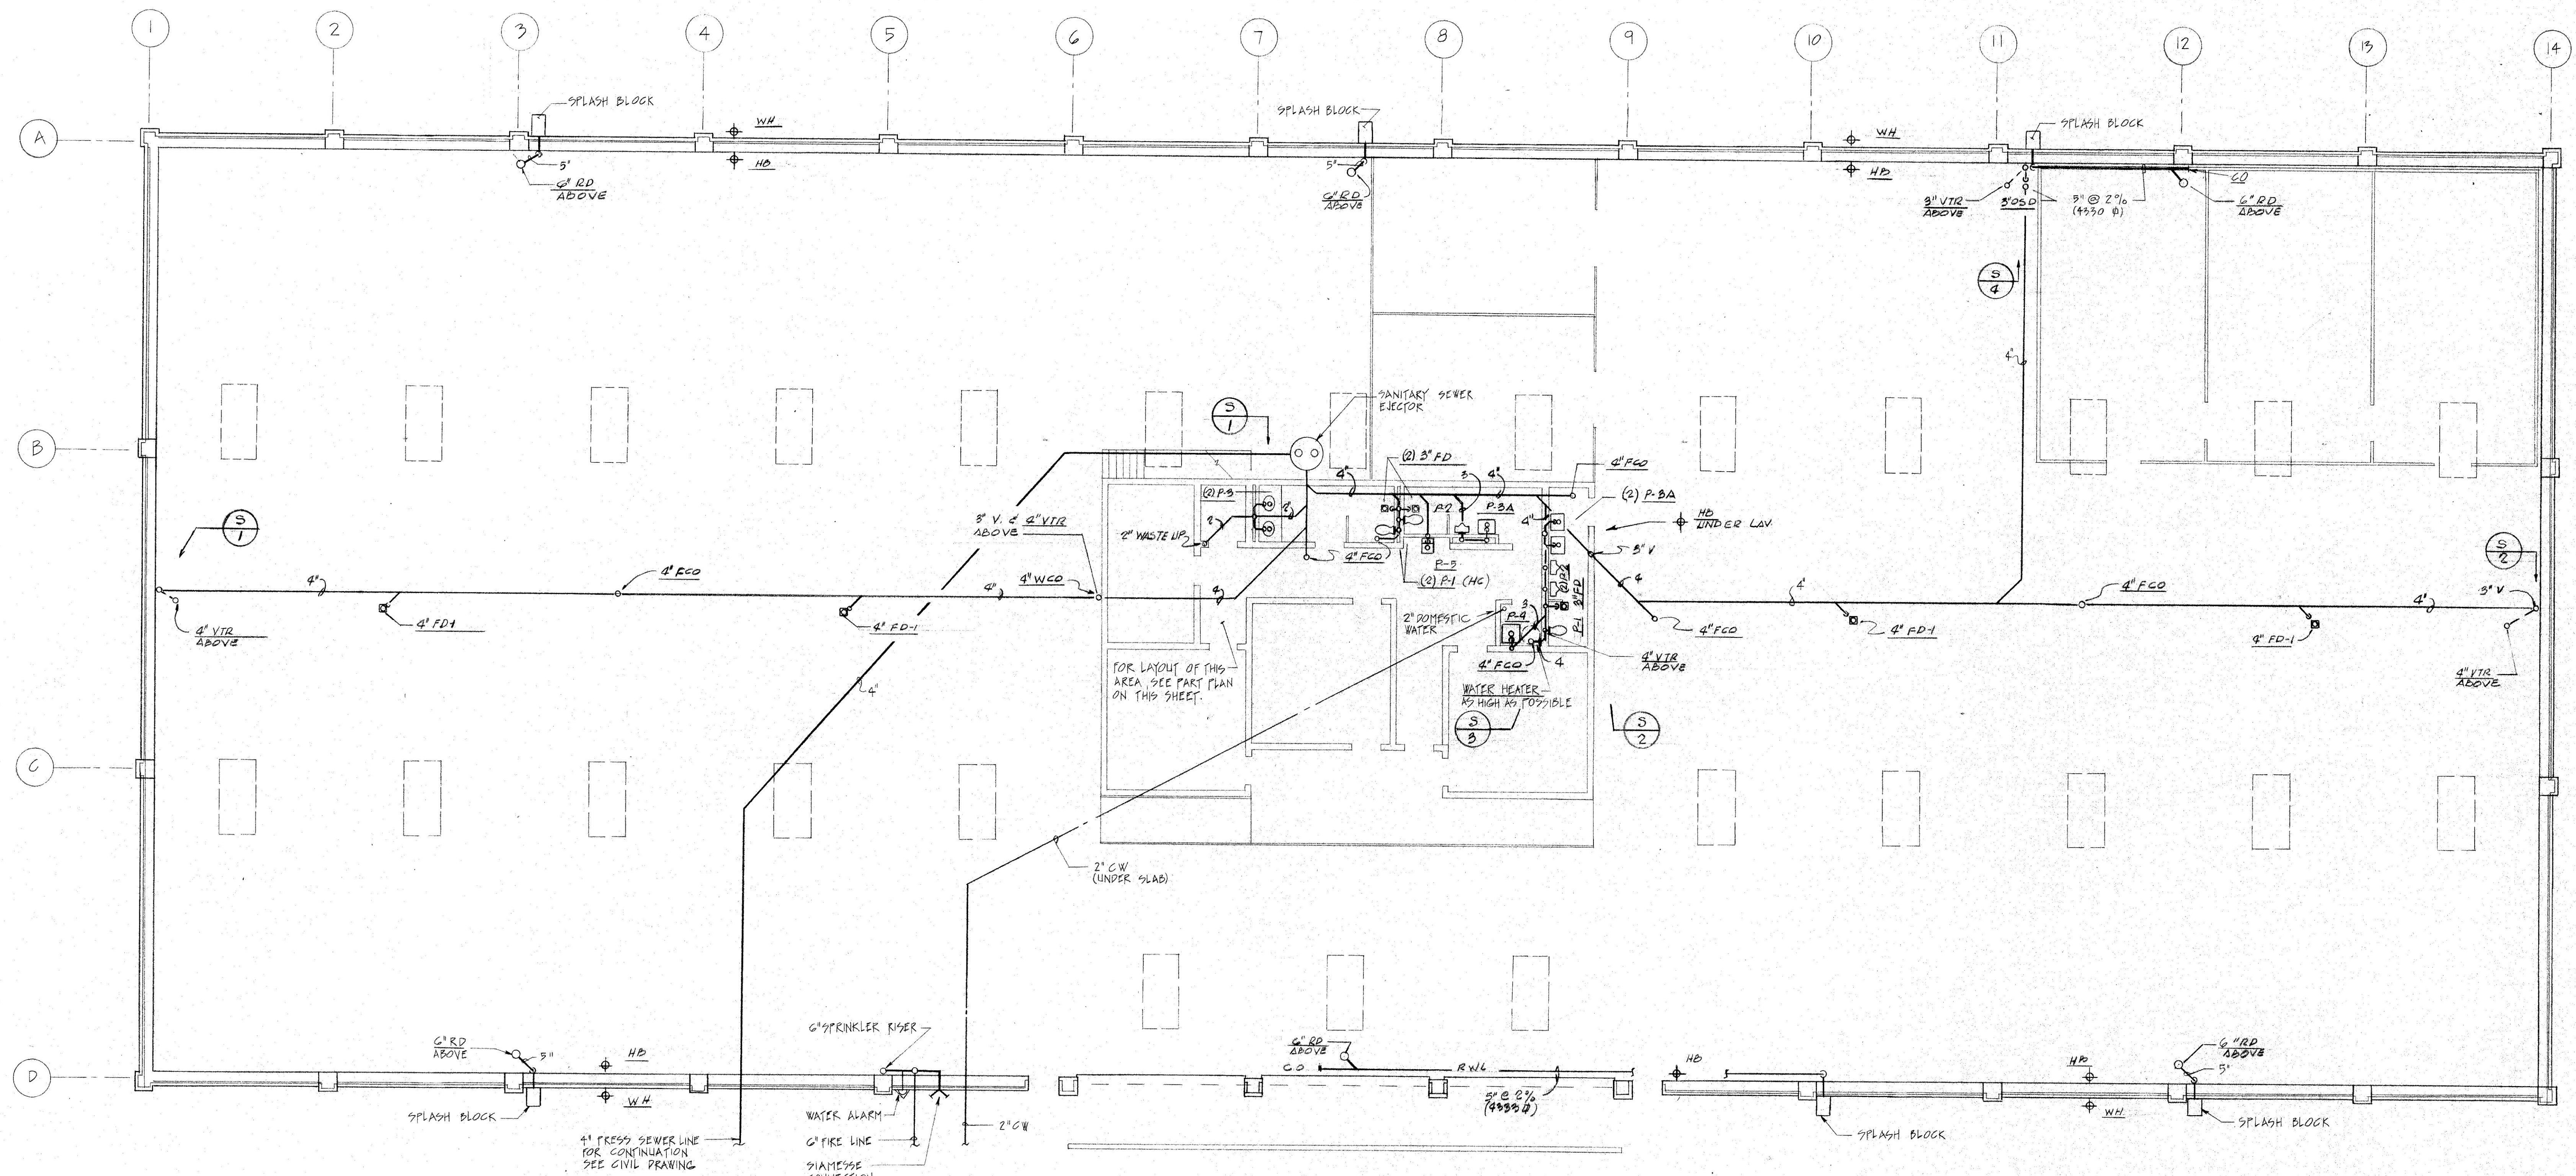

FLOOR PLAN-PLUMBING
SCALE 1/8"=1'-0"

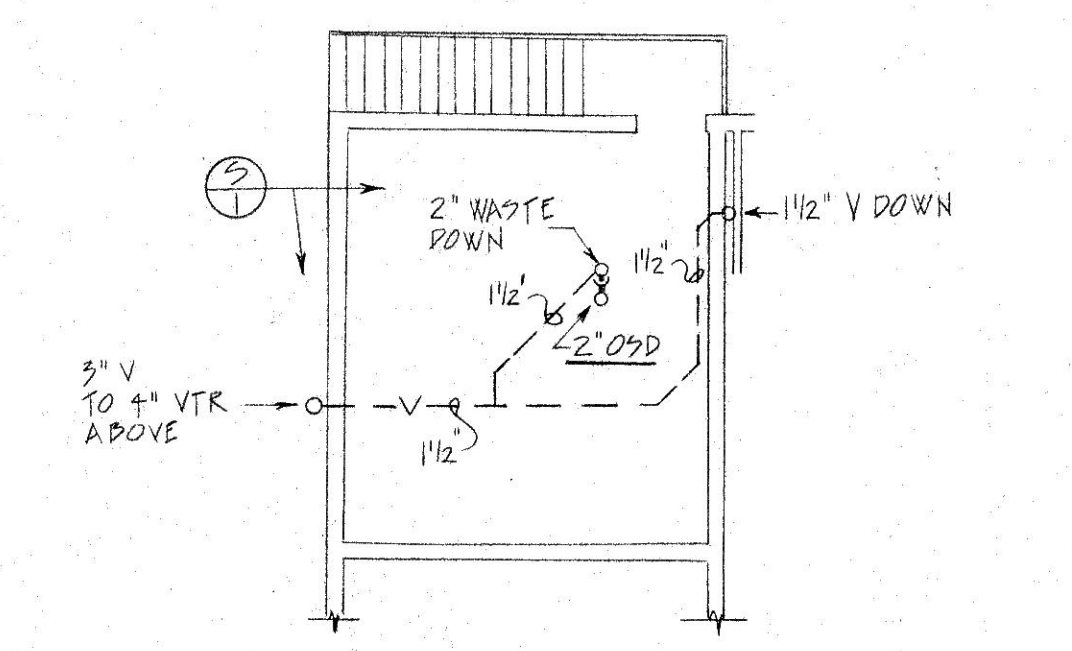

MECHANICAL RM.-PLUMBING
SCALE 1/8"=1'-0"

CHIEF BUREAU OF BUILDING CONSTRUCTION SERVICES Bobes, Lorente and Associates, Inc. Consulting Engineers (301) 230-2682 5020 Nicholson Court, Suite 208 KENSINGTON, MARYLAND 20895	DESIGNED					
	DRAWN					
	CHECKED					
	CERTIFICATION	REVISION	DATE	DESCRIPTION	BY	APP.
	PROJECT DRAWINGS					
	RELOCATION OF COMMISSARY LORTON, VIRGINIA					
	ARCHITECTS - SPACE PLANNERS - INTERIOR DESIGNERS 1101 17th Street, N.W., Washington, D.C. 20036 Telephone (202) 872-9020					
	GOVERNMENT OF THE DISTRICT OF COLUMBIA DEPARTMENT OF PUBLIC WORKS					PROJECT NO. C-17
	DATE					DATE
	DATE					SHEET OF
						P-1

