


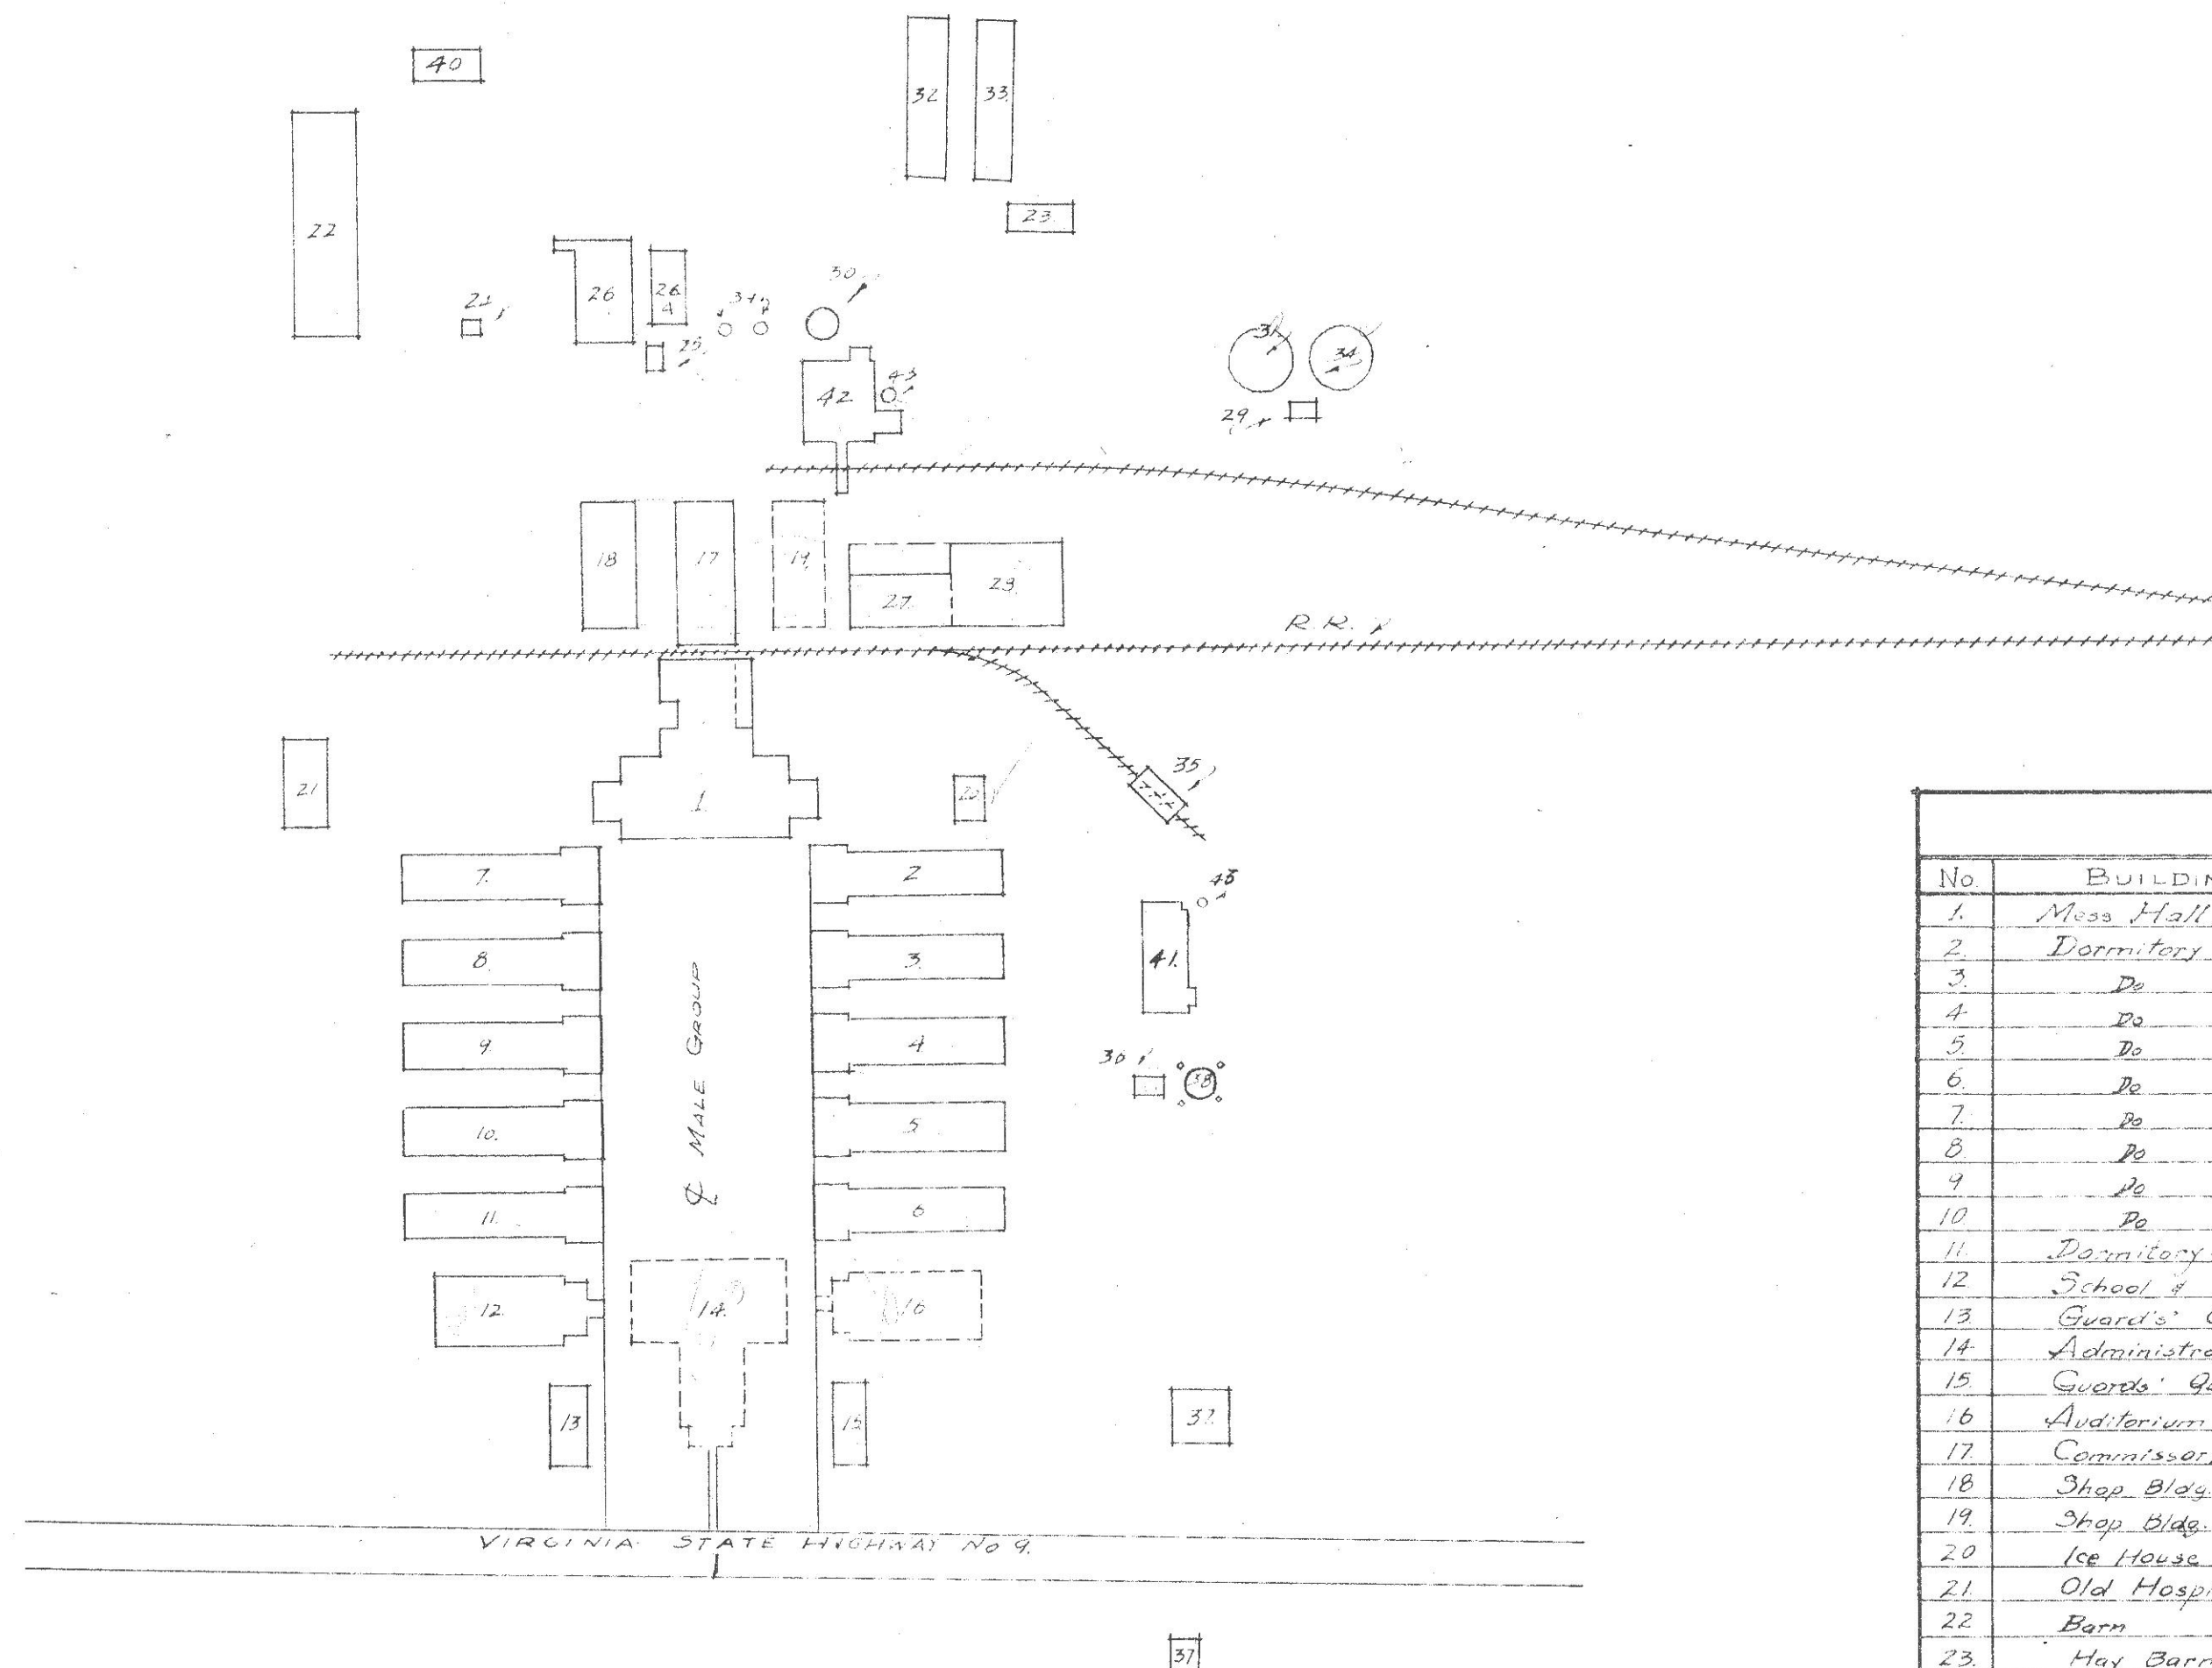


KEY:

No	BUILDING	No	BUILDING
1.	Mess Hall & Kitchen	28	Lumber Shed
2.	Dormitory	29	Filter House, Chem. Contr.
3.	Do	30	Storage Tank
4.	Do	31	Filter
5.	Do	32	Calf Sheds
6.	Do	33	Do
7.	Do	34	Filter
8.	Do	35	Locomotive Plant
9.	Do	36	Pump House
10.	Do	37	Residences
11.	Dormitory, Quarantine	38	50,000 Gal. Tank
12.	School & Hospital	39	Concrete Siles
13.	Guard's Quarters	40	Blacksmith's Shop
14.	Administration Bldg.	41.	Old Heating Plant
15.	Guard's Quarters	42	New Heating Plant
16.	Auditorium	43	Smoke Stacks
17.	Commissary		
18.	Shop Bldg.		
19.	Shop Bldg.		
20.	Ice House		
21.	Old Hospital		
22.	Barn		
23.	Hay Barn		
24.	Veterinary's Office		
25.	Granary		
26.	Dairy Barn		
26A	Dairy Annex		
27.	Tool Storage Bldg.		

705.54'

2x7 06

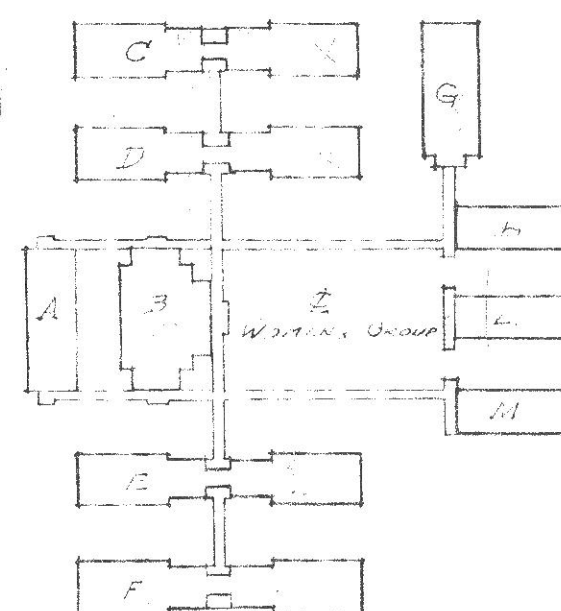

OFFICE OF CONSTRUCTION ENGINEER		
D.C. PENAL INSTITUTIONS, LOS ANGELES		
Diagrammatic Location Of Building		
- WORKHOUSE		
Scale: 1" = 50'		
DRAWN BY:	CHECKED BY:	DATE:
C. J. F. H.	J. J. F. H.	JUL 22 1931