


Section "AA"

Circuits

- 1 Arcade lights
- 2 Officer's light - receptacle
- 3 Front corridor and rear lights
- 4 Outside lights
- 5 Corridor lights - alternate a b c d
- 6 " " " " " "
- 7 " " " " " "
- 8 " " " " " "
- 9 Second floor tier - service corridor
- 10 First " " " "
- 11 Exhaust fans - four
- 12 Cells 1 to 12
- 13 " 14 to 25
- 14 " 26 to 37
- 15 " 38 to 50
- 16 " 51 to 62
- 17 " 63 to 75
- 18 " 76 to 87
- 19 " 88 to 100
- 20 - 4 SHOWER ROOMS,

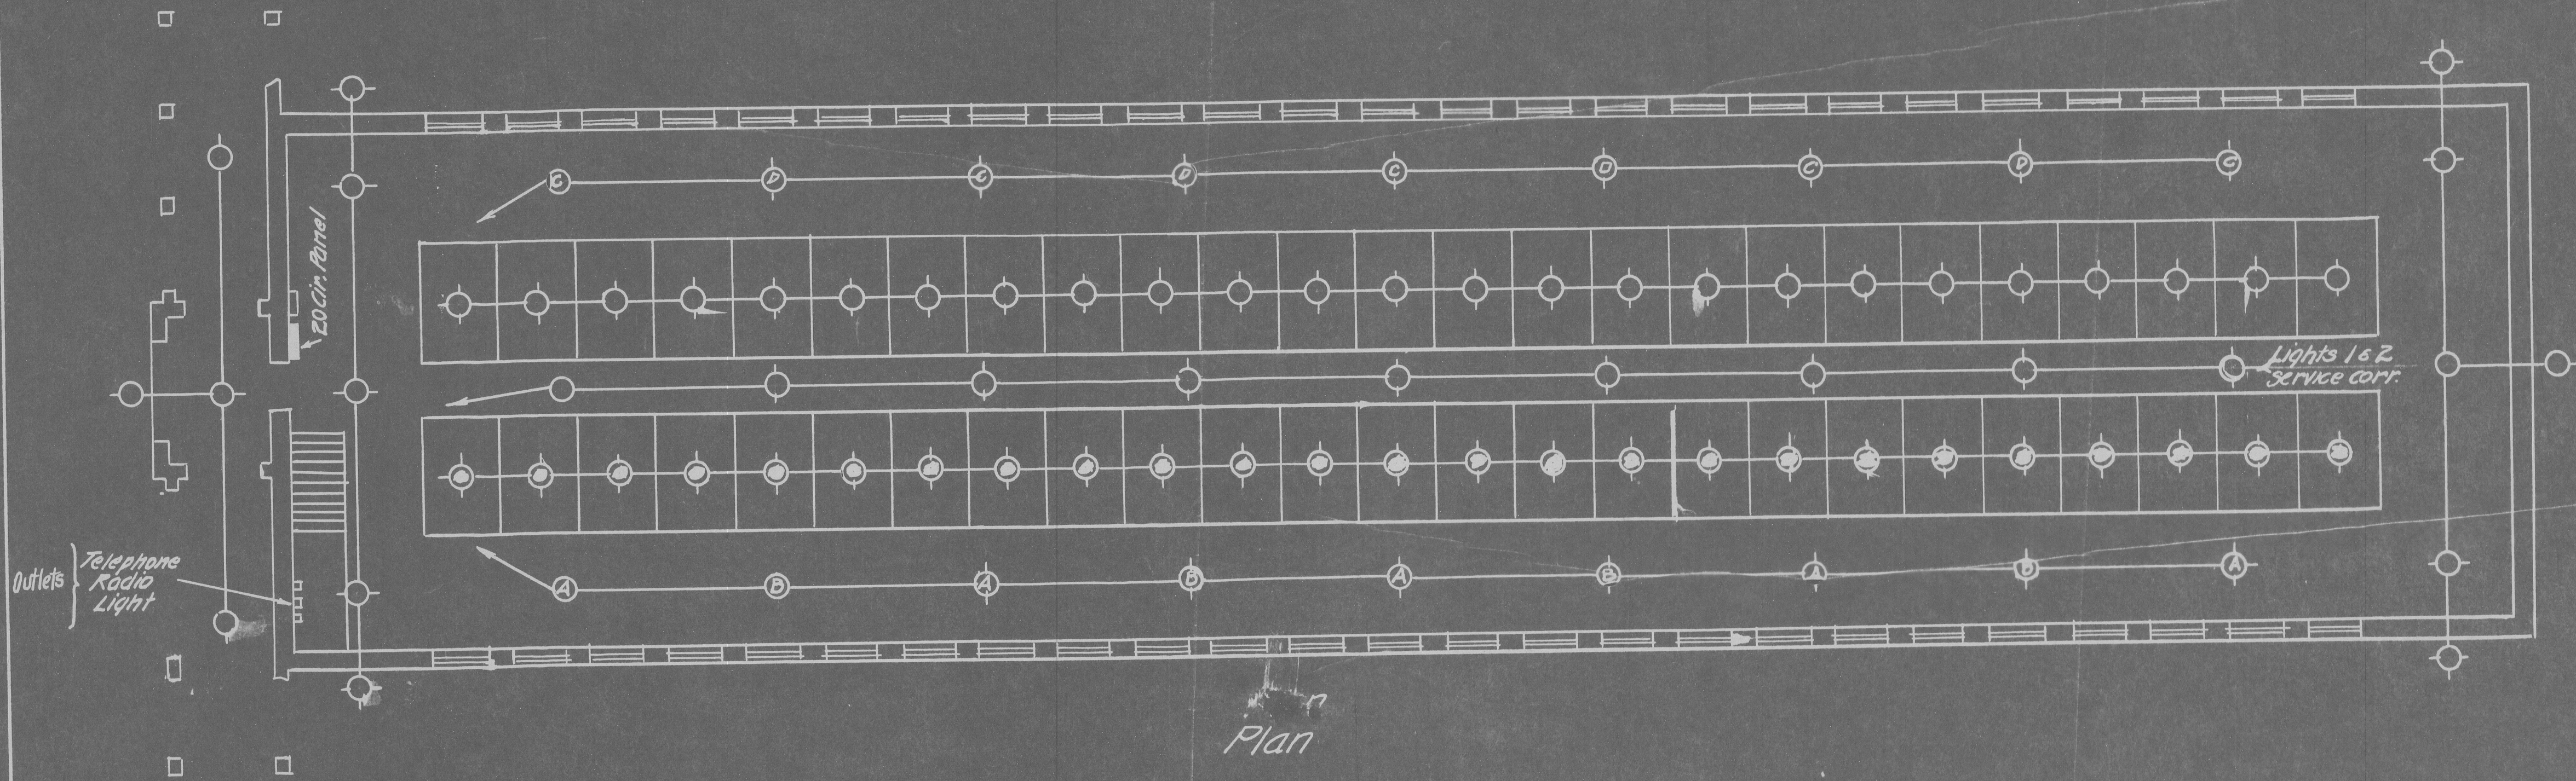

Plan

Approved *W. H. K. 8/15/40*
as to electrical details

Constructing Engineer's Office D.C. Penal Institutions - Lorton, Va.		
Electrical Layout - Cell Bldg. #6 Reformatory - Lorton, Va.		
Scale - 1/8" = 1'-0"		
Traced by	Checked by	Date
Deming	H. J. H. [unclear]	8-12-40