




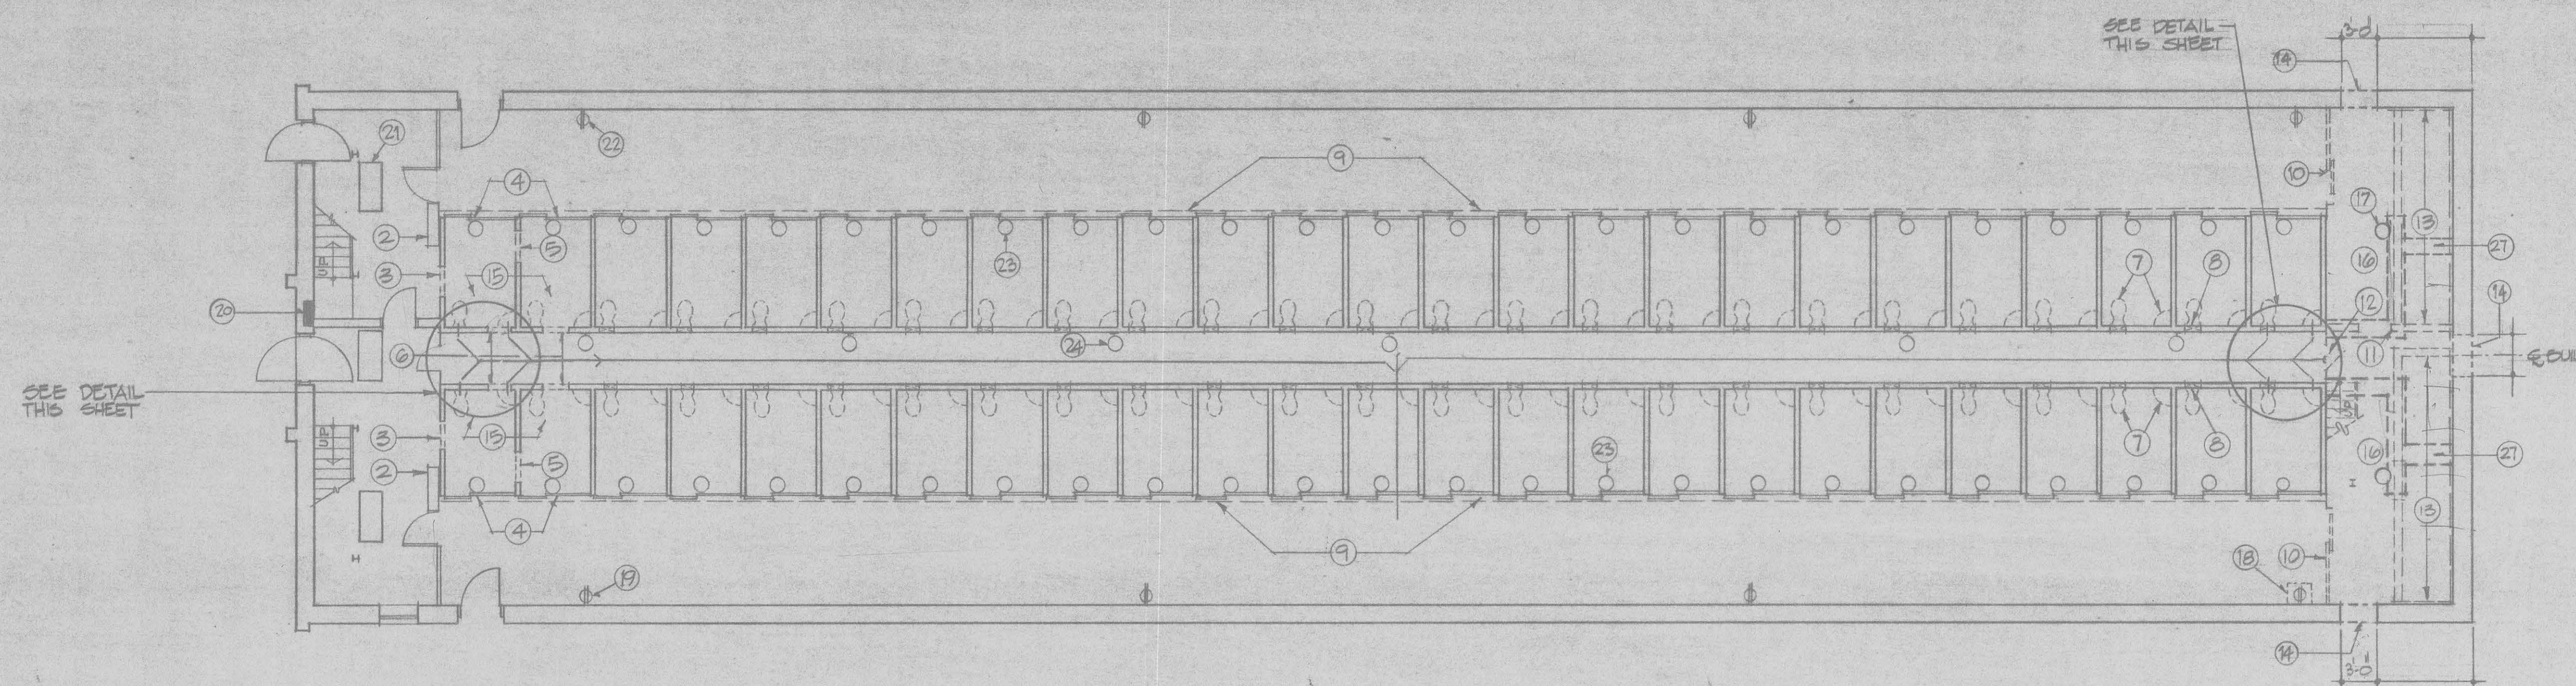


FIRST FLOOR PLAN
SCALE: 1/8" = 1'-0"

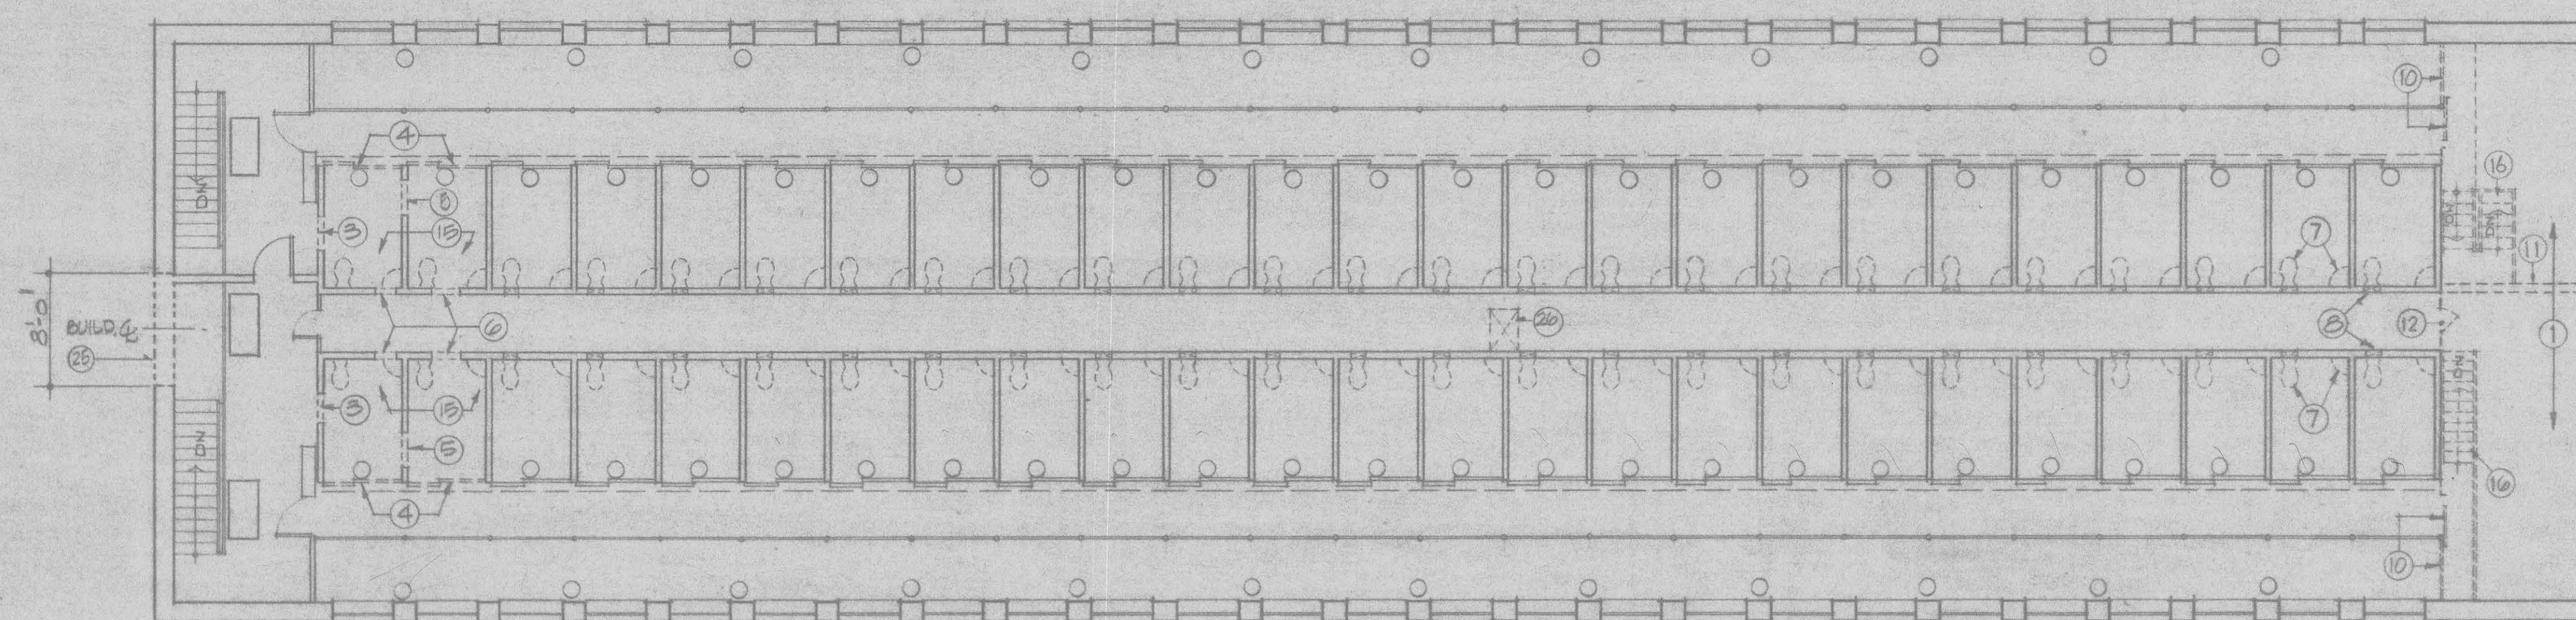


SECOND FLOOR PLAN
SCALE: 1/8" = 1'-0"

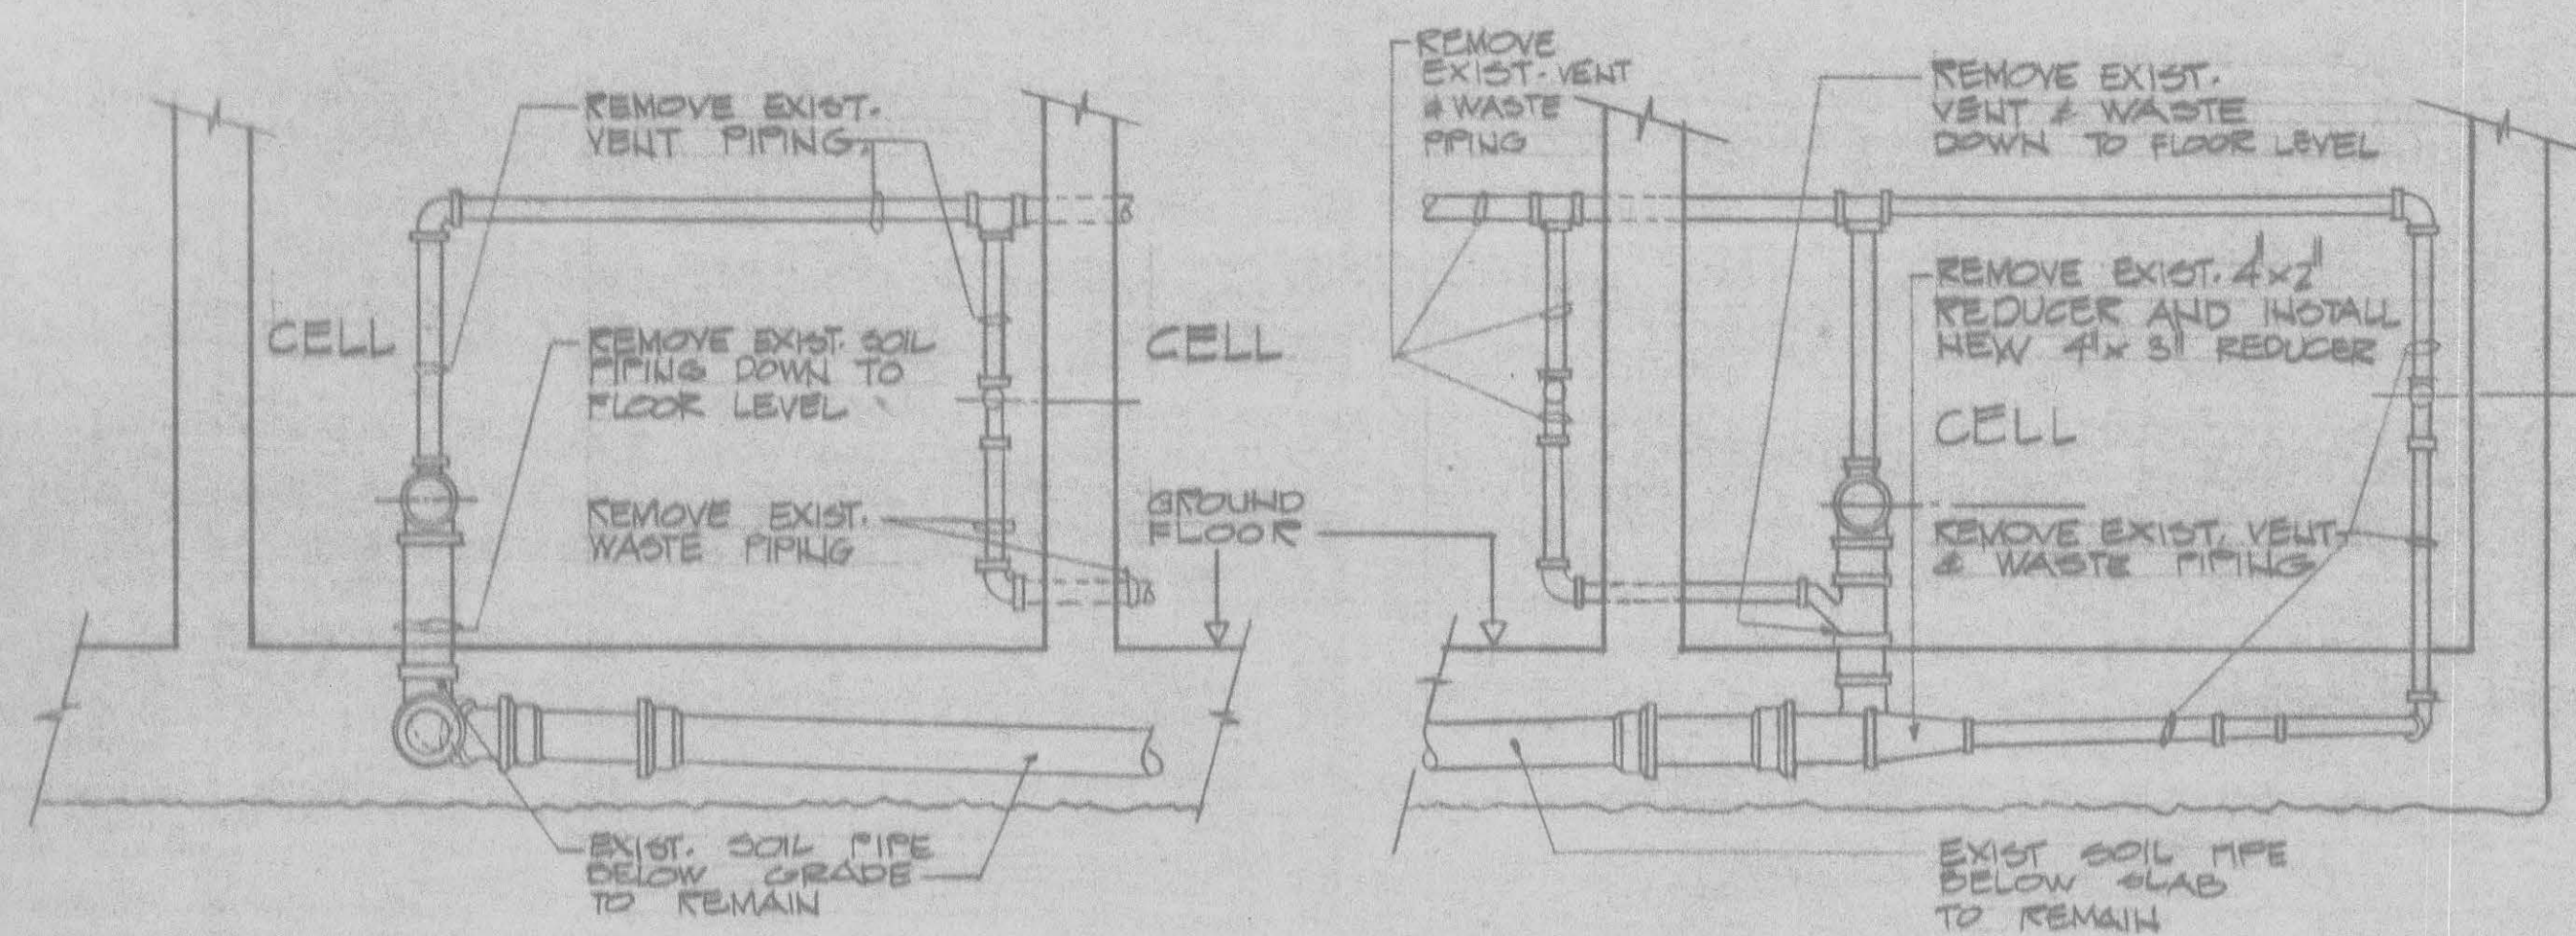

TYPICAL REMOVAL DETAIL
WITH WATER CLOSET
AT END OF BRANCH SEWER
NO SCALE

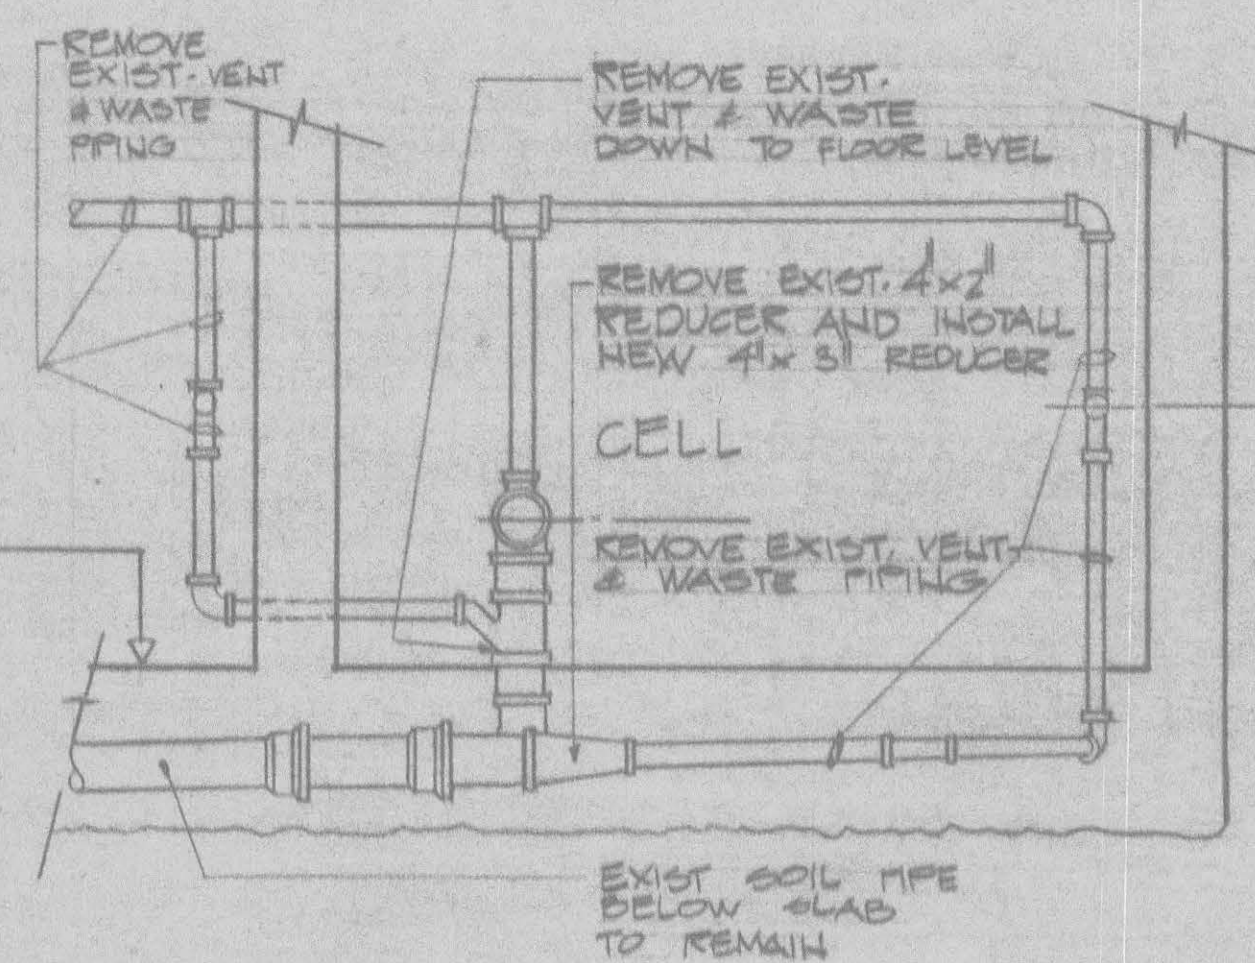

TYPICAL REMOVAL DETAIL
WITH LAVATORY
AT END OF BRANCH SEWER
NO SCALE

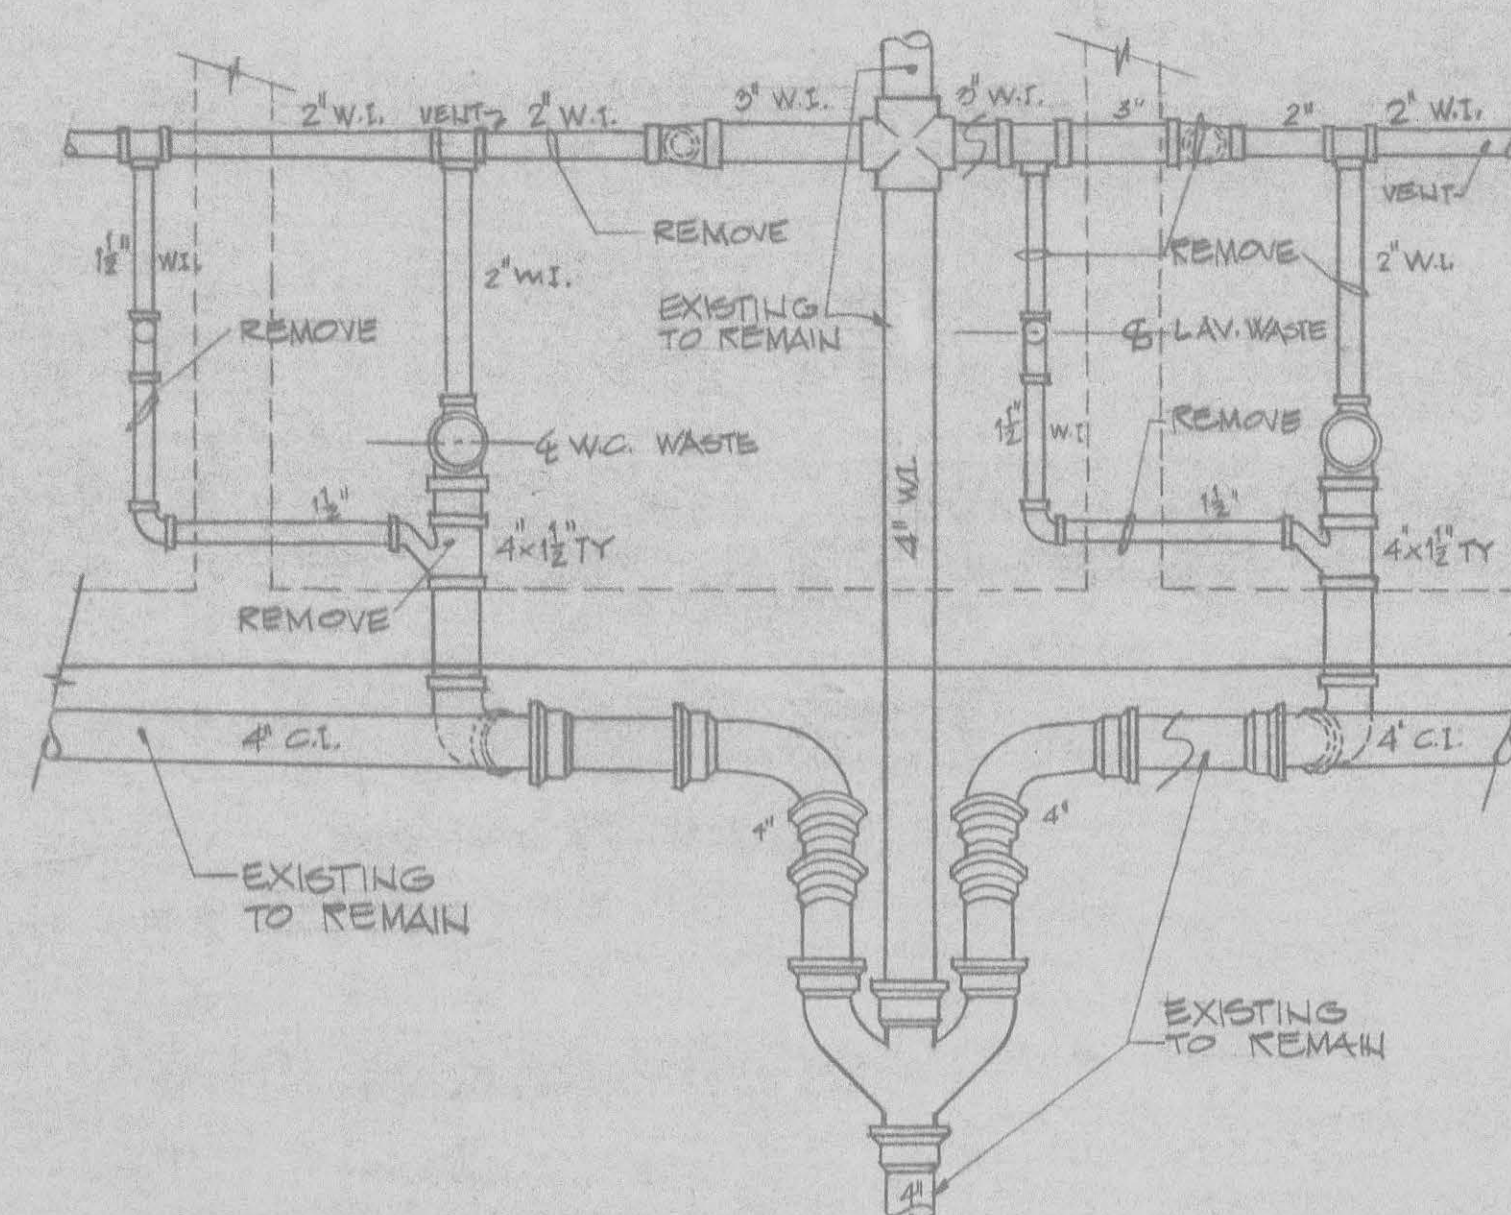

TYPICAL EXIST. STACK CONNECTION DETAIL
NO SCALE

DEMOLITION NOTES:

1. PROTECT ALL EXISTING AREAS, NOT AFFECTED BY NEW WORK FROM DAMAGE DURING DEMOLITION.
2. RESTORE AREAS TO REMAIN, DAMAGED BY DEMOLITION, TO ORIGINAL CONDITION.
3. DEMOLITION INDICATED IN THIS DRAWING IS ONLY FOR AREAS WHERE NEW WORK IS TO BE DONE. APPROVAL SHALL BE OBTAINED PRIOR TO THE TEMPORARY REMOVAL OF EXISTING ITEMS, CONSIDERED BY THE CONTRACTOR AS INCIDENTALLY NECESSARY FOR THE EXECUTION OF THE WORK.
4. ITEMS INDICATED TO BE REMOVED & REUSED SHALL BE PROTECTED FROM DAMAGE DURING REMOVAL, SAFELY STORED, & RESTORED TO ORIGINAL CONDITION BEFORE REINSTALLATION WHERE INDICATED.
5. ITEMS REMOVED AT CONTRACTOR'S OPTION TO FACILITATE WORK SHALL BE TREATED SAME AS NOTE 4 ABOVE.
6. SYMBOL (2) IN THE DEMOLITION PLAN DENOTES WORK REQUIRED AS FOLLOWS:

1. REMOVE STEEL CEILING GRILLE.
2. REMOVE CELL DOOR LOCKING CABINET
3. CUT OPENINGS IN CONC. WALL FOR 2'-0" X 6'-8" DOOR.
4. REMOVE CELL DOOR & GRILLE WALL
5. CUT OPENINGS IN CONC. WALL 2'-6" W X 7'-4" H.
6. CUT OPENINGS IN CONC. WALL 1'-6" W X 6'-0" H.
7. REMOVE ALL PLUMBING FIXTURES & ANCHORING DEVICES TO WALLS & FLOORS (TYPICAL AT ALL CELLS)
8. CUT OPENINGS IN CONC. WALL 1'-4" W X 1'-8" H., 6'-3" A.F.F.
9. REMOVE ALL DOOR CLOSING & LOCKING MECHANISMS.
10. REMOVE GRILLE WALLS & DOORS.
11. REMOVE MASONRY WALL & DOOR.
12. REMOVE STEEL PLATE WALL & ACCESS DOORS.
13. REMOVE R.T. FLOOR, CERAMIC TILE FINISH @ WALLS, LOW PARTITIONS, FLOOR DRAINS & SHOWER HEADS & PIPING.
14. CUT OPENING IN EXTERIOR MASONRY WALL FOR 3'-0" X 6'-8" DOOR. (SHORE TOP OF OPENING UNTIL INSTALLATION OF LINTEL)
15. CUT FLOOR SLAB AS REQUIRED FOR THE INSTALLATION OF NEW PLUMBING FIXTURES (W.C., LAV., SHOWERS & SINKS)
16. REMOVE STAIR, PLATFORM, SUPPORTS & CONNECTIONS TO WALLS.
17. CEILING MOUNTED INCANDESCENT LIGHTING FIXTURES IN SHOWER AREA TO BE REMOVED (TYPICAL FOR 2 FIXTURES)
18. ELECT. WTR. COOLER TO BE REMOVED
19. RECEPTACLES TO BE REMOVED (TYPICAL FOR 4)
20. PANELBOARD TO BE REMOVED
21. CEILING MOUNTED FLUORESCENT LIGHTING FIXTURES TO BE REMOVED (TYPICAL FOR 2 FIXTURES)
22. RECEPTACLES TO BE REMOVED (TYPICAL OF 4)
23. CEILING MOUNTED INCANDESCENT LIGHTING FIXTURES TO BE REMOVED (TYPICAL OF 50 FIXTURES)
24. WALL MOUNTED INCANDESCENT LIGHTING FIXTURES TO BE REMOVED (TYPICAL FOR 6 FIXTURES)
25. CUT OPENING IN EXTERIOR MASONRY WALL FOR 6'-0" X 4'-6" LOUVER (SHORE TOP OF OPENING UNTIL INSTALLATION OF LINTEL)
26. CUT CONC. IN CLR FOR 2'-0" X 3'-0" OPENING COORDINATE LOCATION WITH GENERAL CONTRACTOR.
27. CUT FLOOR SLAB 1'-6" WIDE, CENTERED OVER NEW MASONRY WALL, REMOVE GRAVEL & SOIL TO 8" DEPTH.



1/8" = 1'-0"
scale
0 5 10 15 20
feet

DESIGNED					
DRAWN					
CHECKED					
CERTIFICATION	REVISION	DATE	DESCRIPTION	BY	APP
PROJECT DRAWINGS					
DEMOLITION OF BUILDING P-2				DRAWING NO	
RENOVATION OF BUILDING P2, P4, P6				D-1	
MAXIMUM SECURITY AREA					
DEPT. OF CORRECTIONS - LORTON					
ASSISTANT DIRECTOR FOR BUREAU OF DESIGN AND ENGINEERING	REGISTRATION NO. A-409	DATE 1973	LBC&W VIRGINIA	GOVERNMENT OF THE DISTRICT OF COLUMBIA	PROJECT NO. 880471
DATE	ARCHITECT	DATE	PLANNERS	DEPARTMENT OF GENERAL SERVICES	DATE 2-22-1979
					SHEET 2 OF 21