




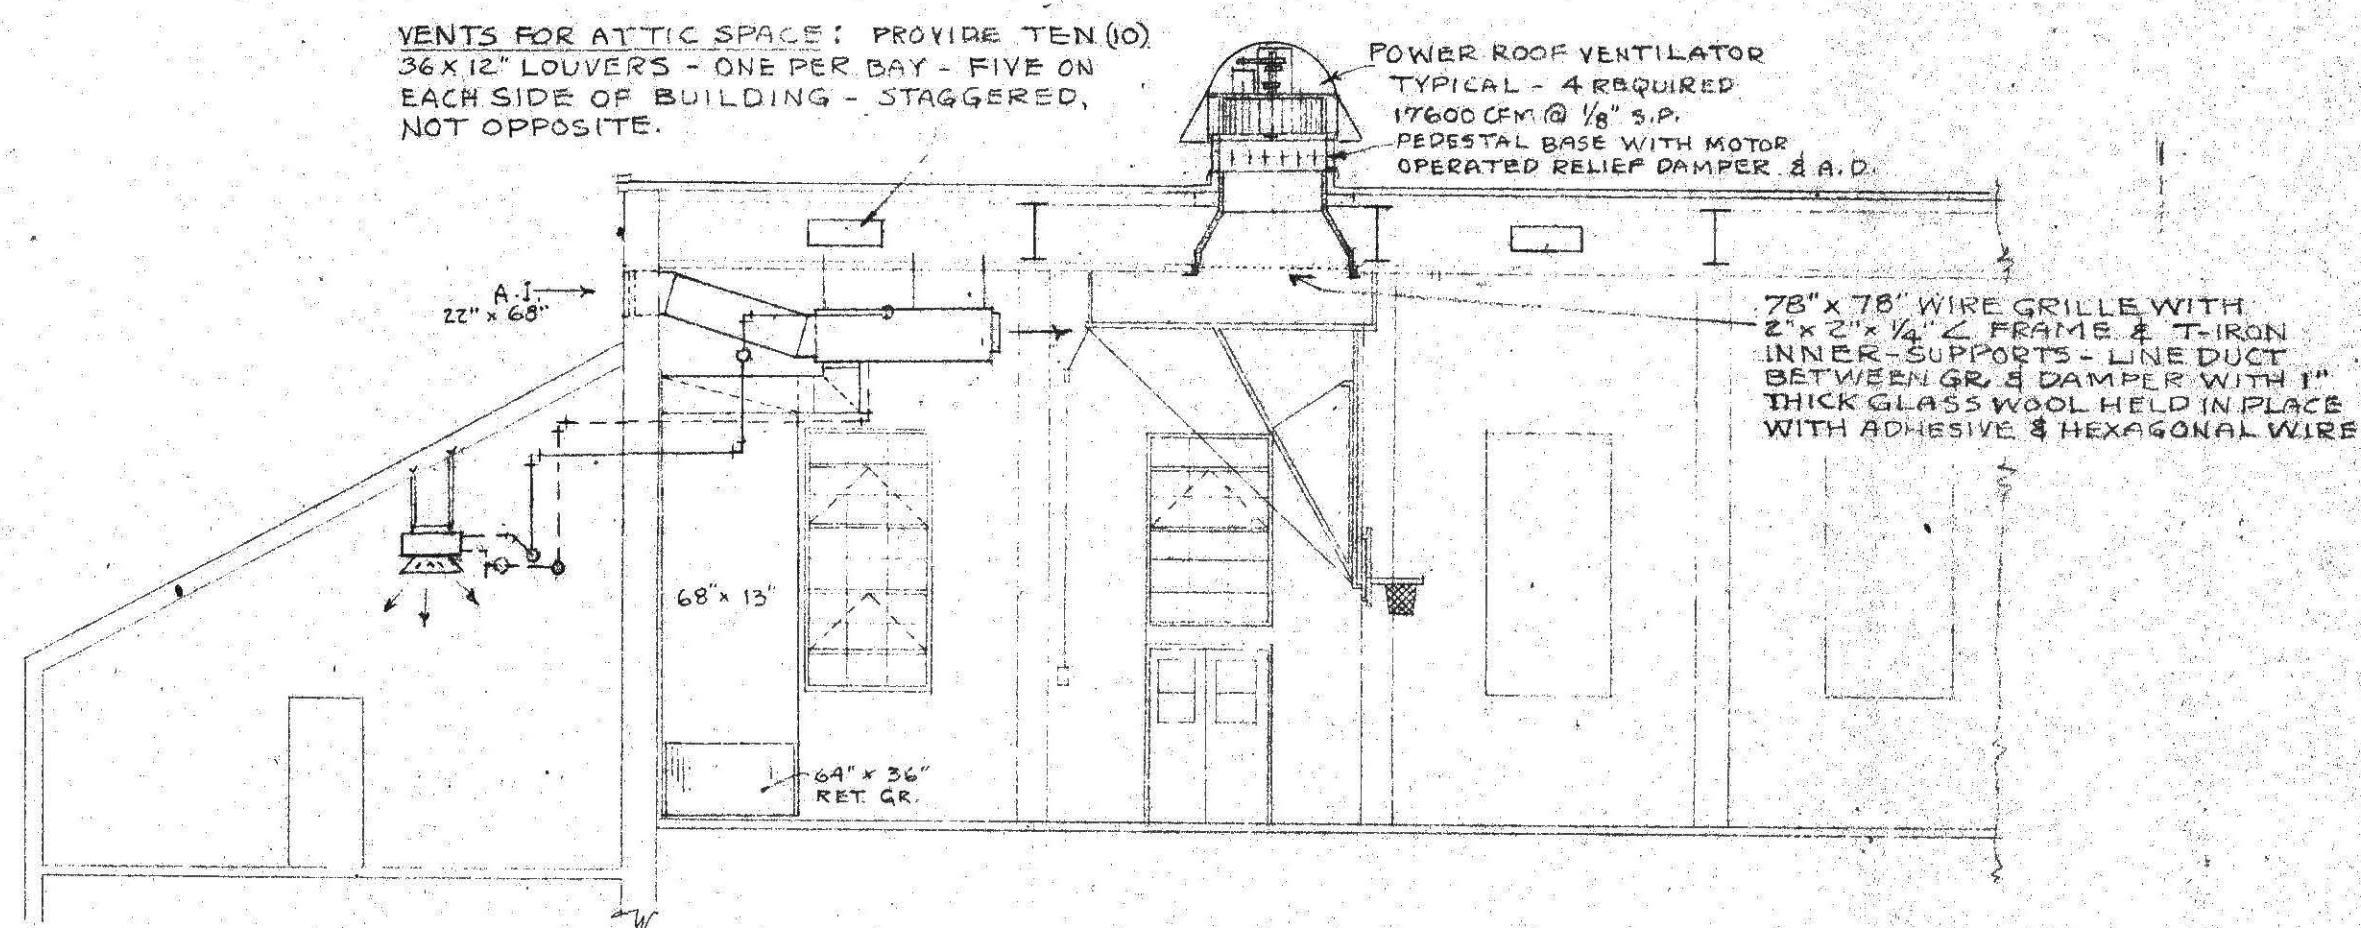

SECTION A-A NORTH END
SCALE 1/8" = 1'-0"

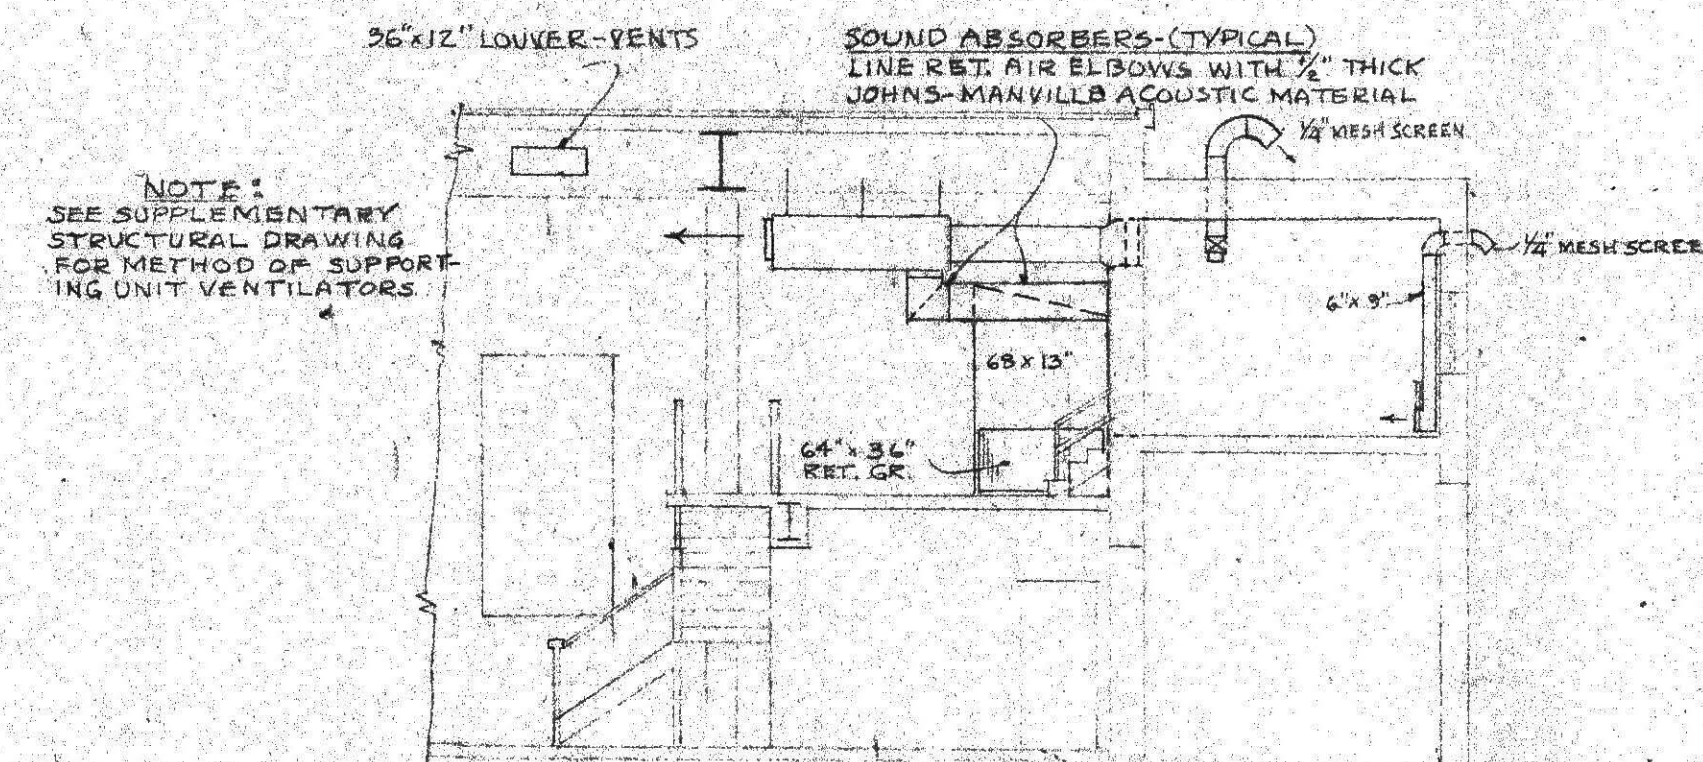


SECTION A-A SOUTH END

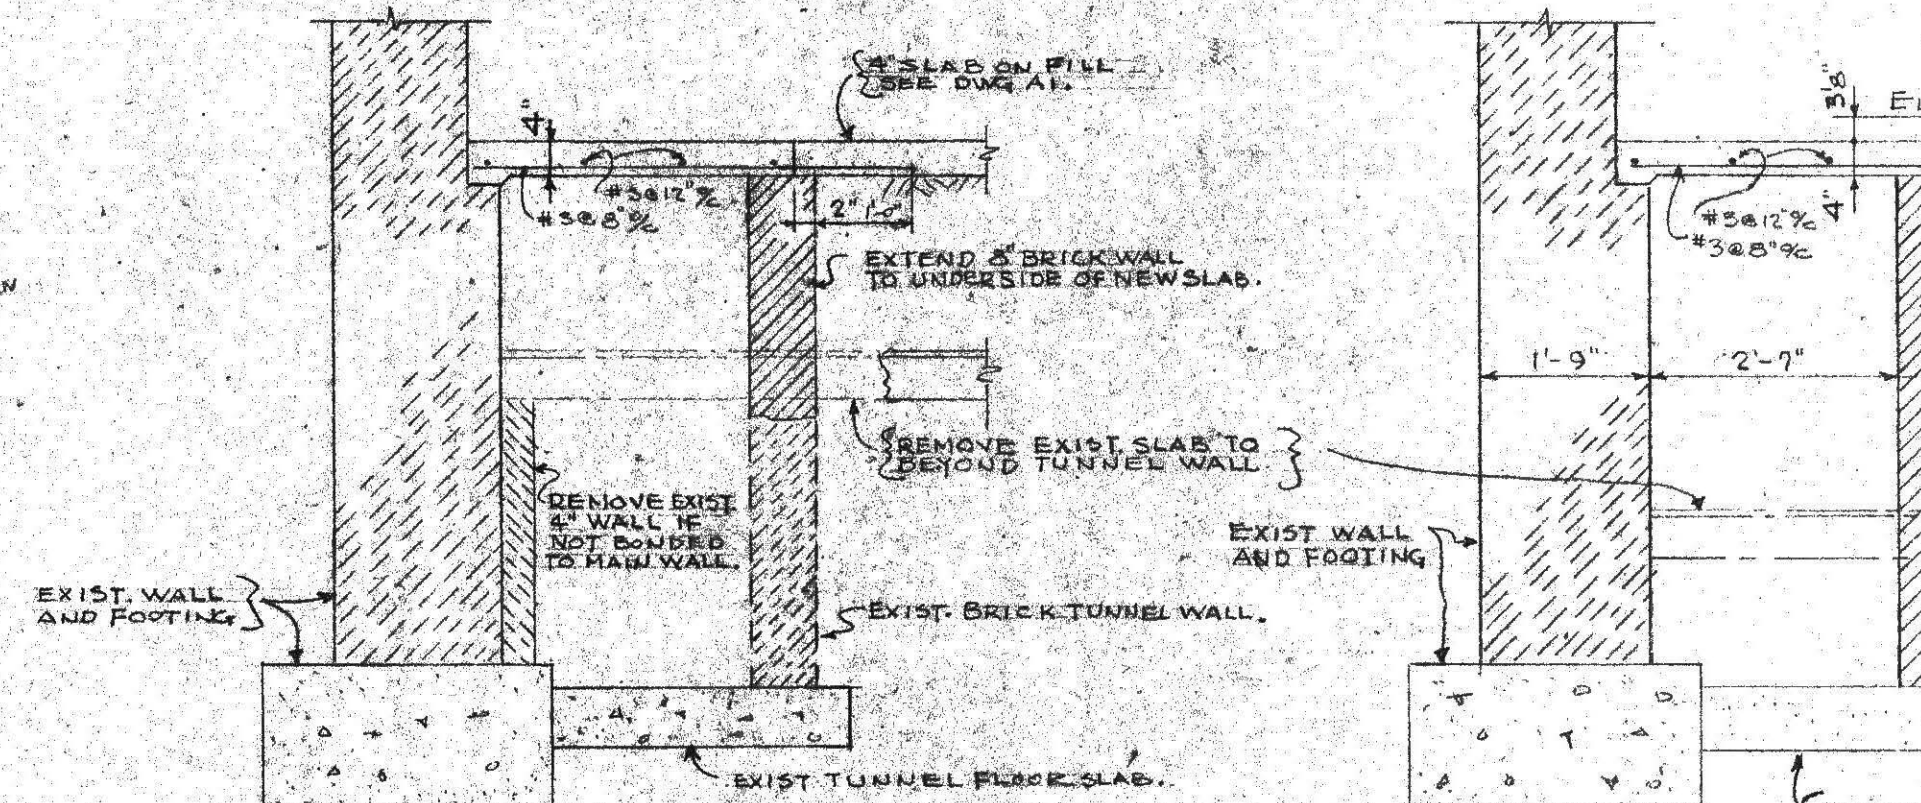


SECTION THROUGH EXISTING TUNNEL
SCALE 1/2" = 1'-0"

SECTION TH NEW TUNNEL
SCALE 1/2" = 1'-0"

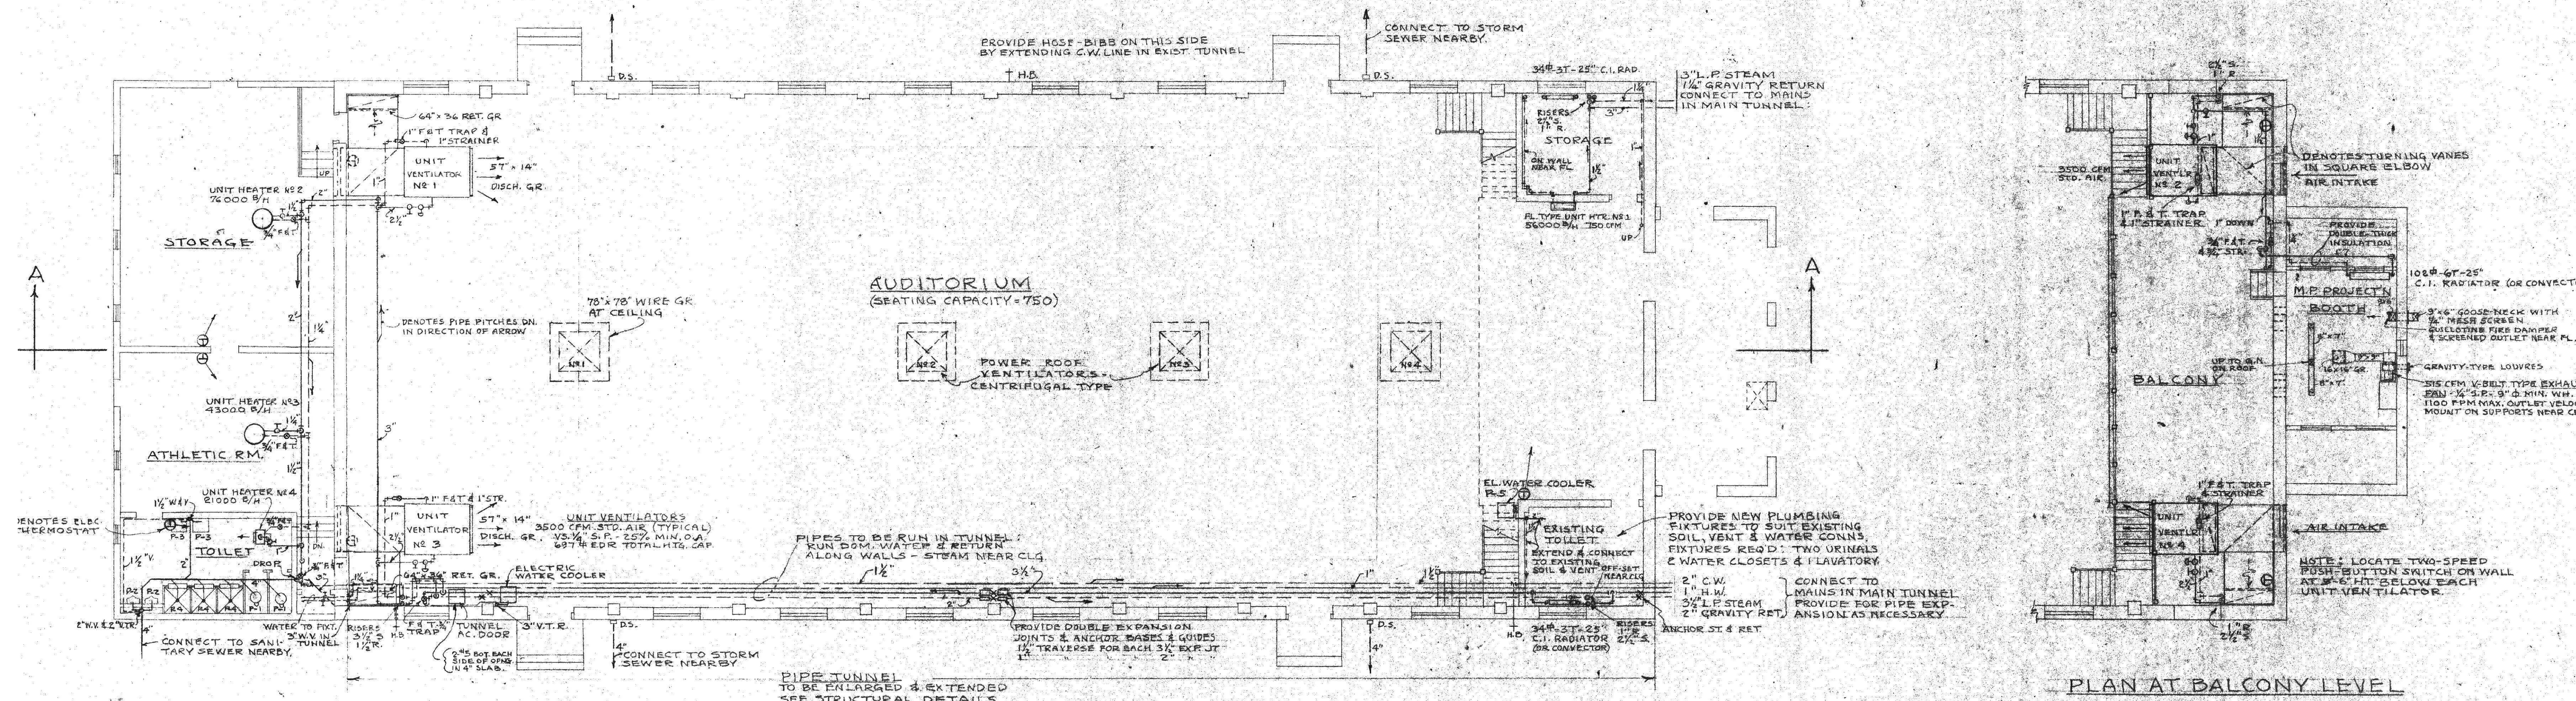

MAIN FLOOR PLAN
SCALE 1/8" = 1'-0"

PLAN AT BALCONY LEVEL

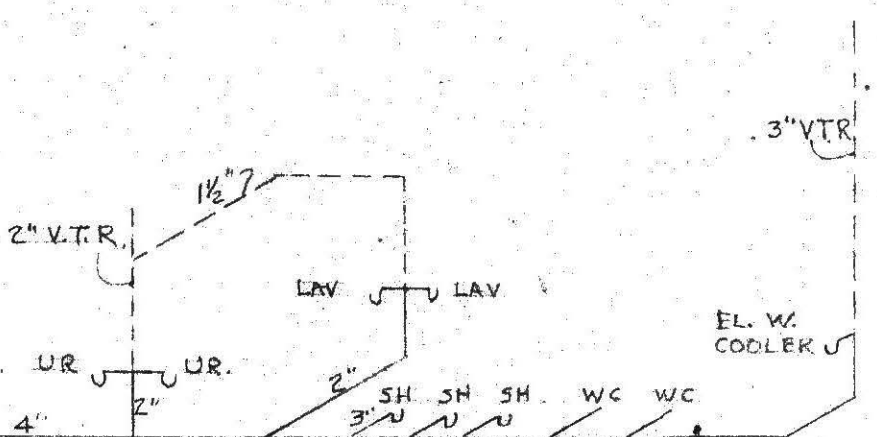

PLUMBING RISER DIAGRAM
NO SCALE

HEATING, VENTILATING & PLUMBING S	
Designed <u>BHW</u>	RECONSTRUCTION OF AUDITORIUM D.C. REFORMATORY LORTON, VIRGINIA
Drawn <u>BHW</u>	
Checked <u>WEA</u>	
Branch Chief <u>[Signature]</u>	
Date <u>4-28-56</u>	
Revisions	
<u>P. E. C. [Signature]</u> CHIEF OF DESIGN & ENGINEERING DIVISION	GOVERNMENT OF THE DISTRICT OF COLUMBIA DEPARTMENT OF BUILDINGS AND GROUNDS OFFICE OF DESIGN AND ENGINEERING