




P-241

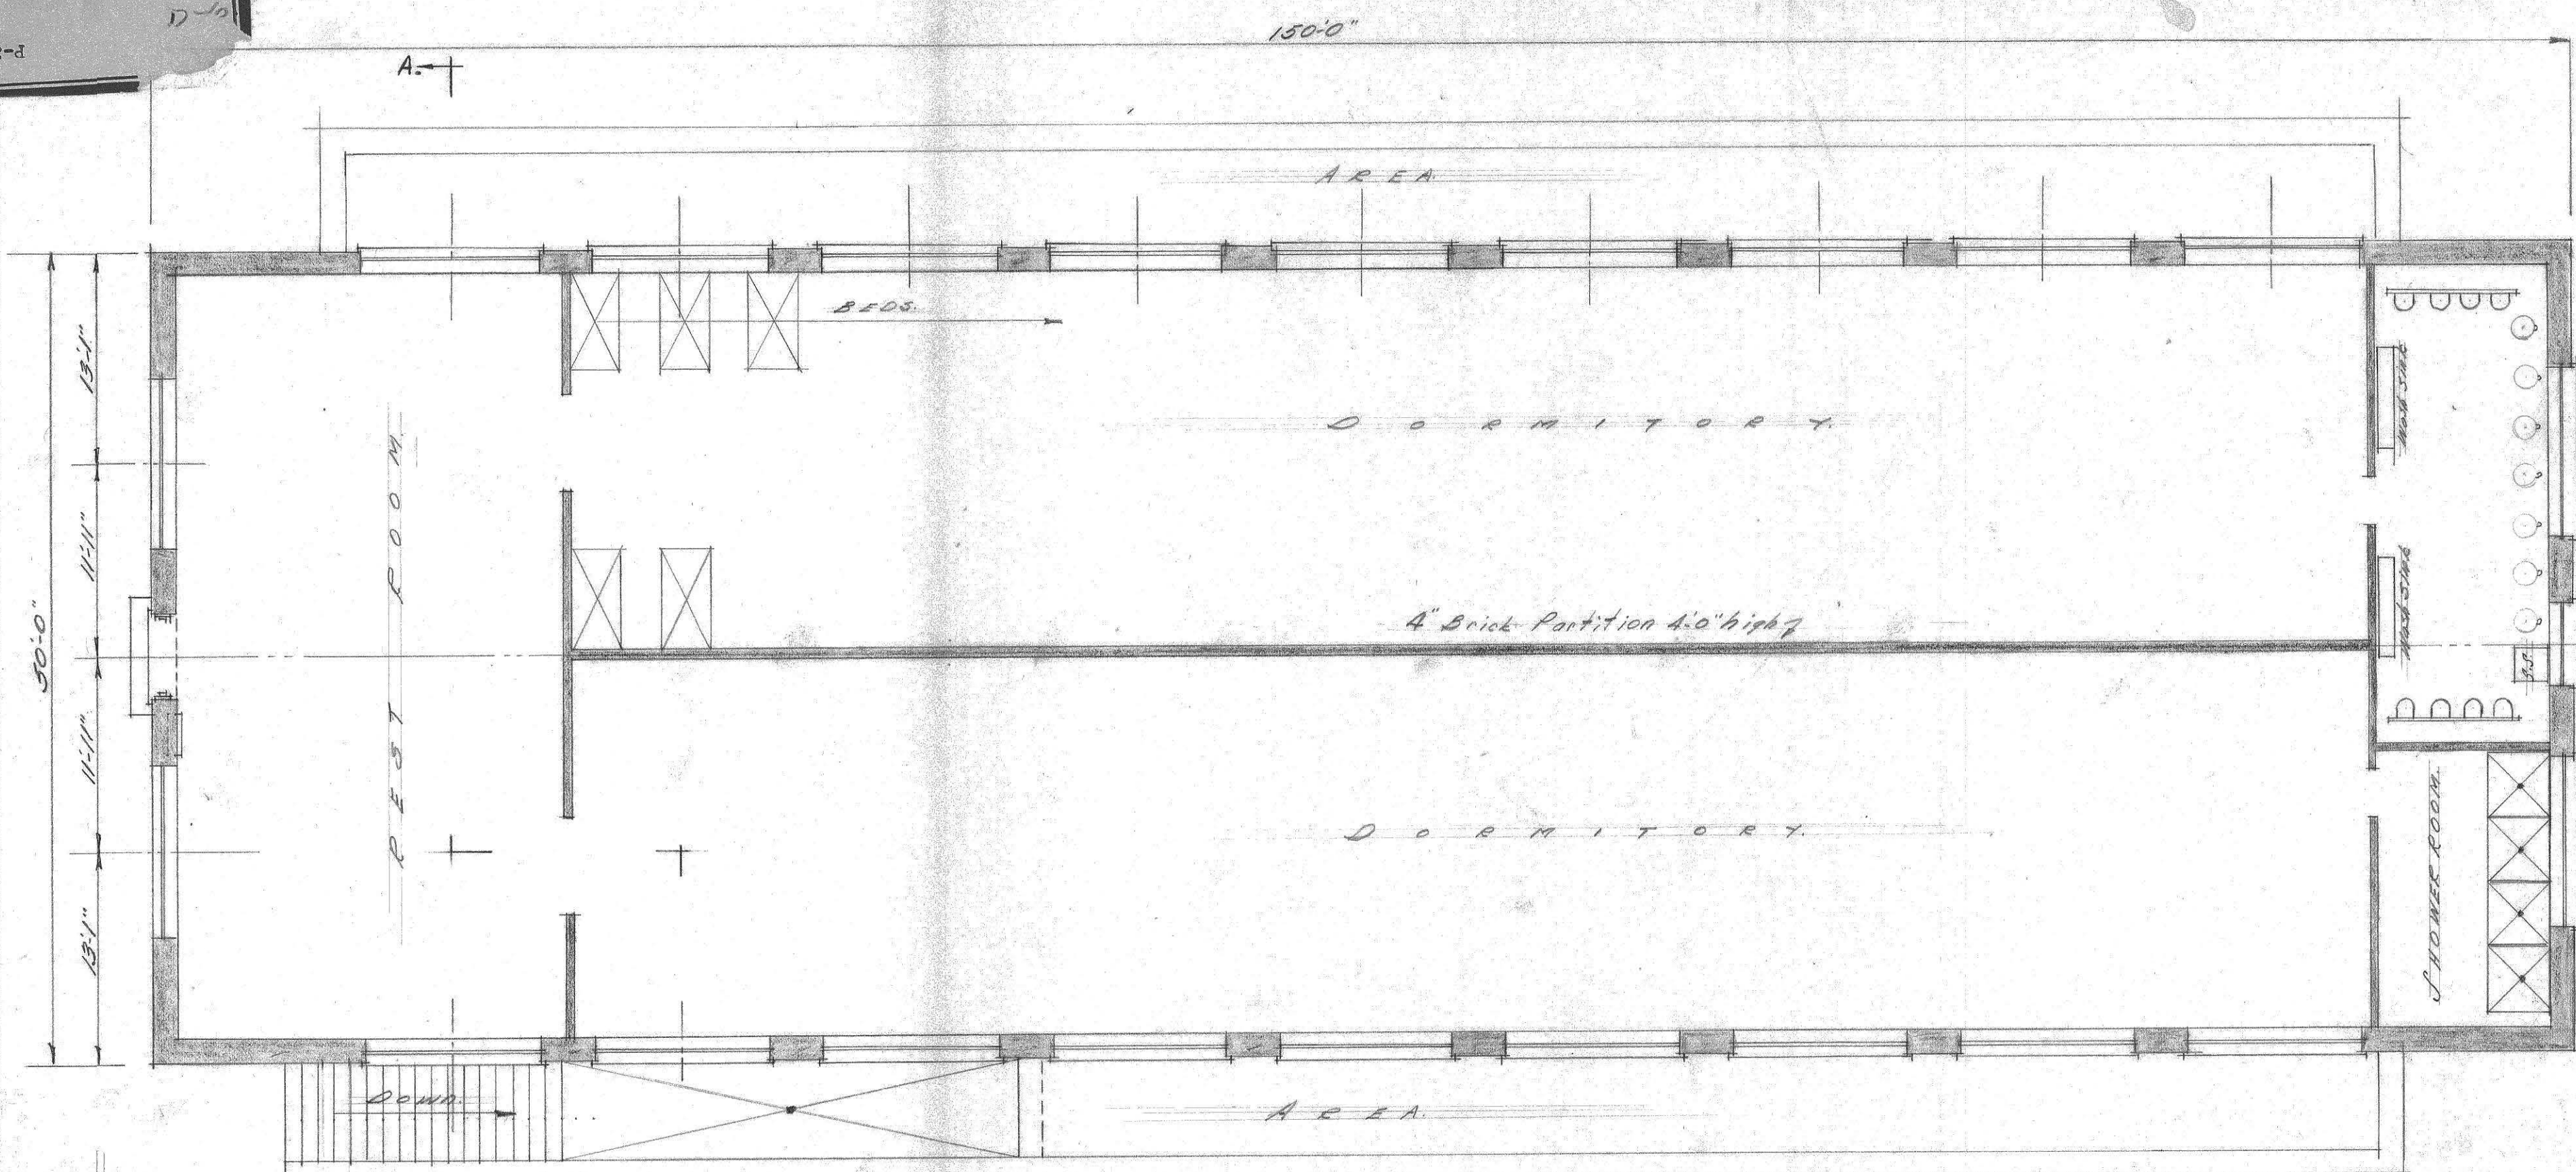

FIRST FLOOR PLAN

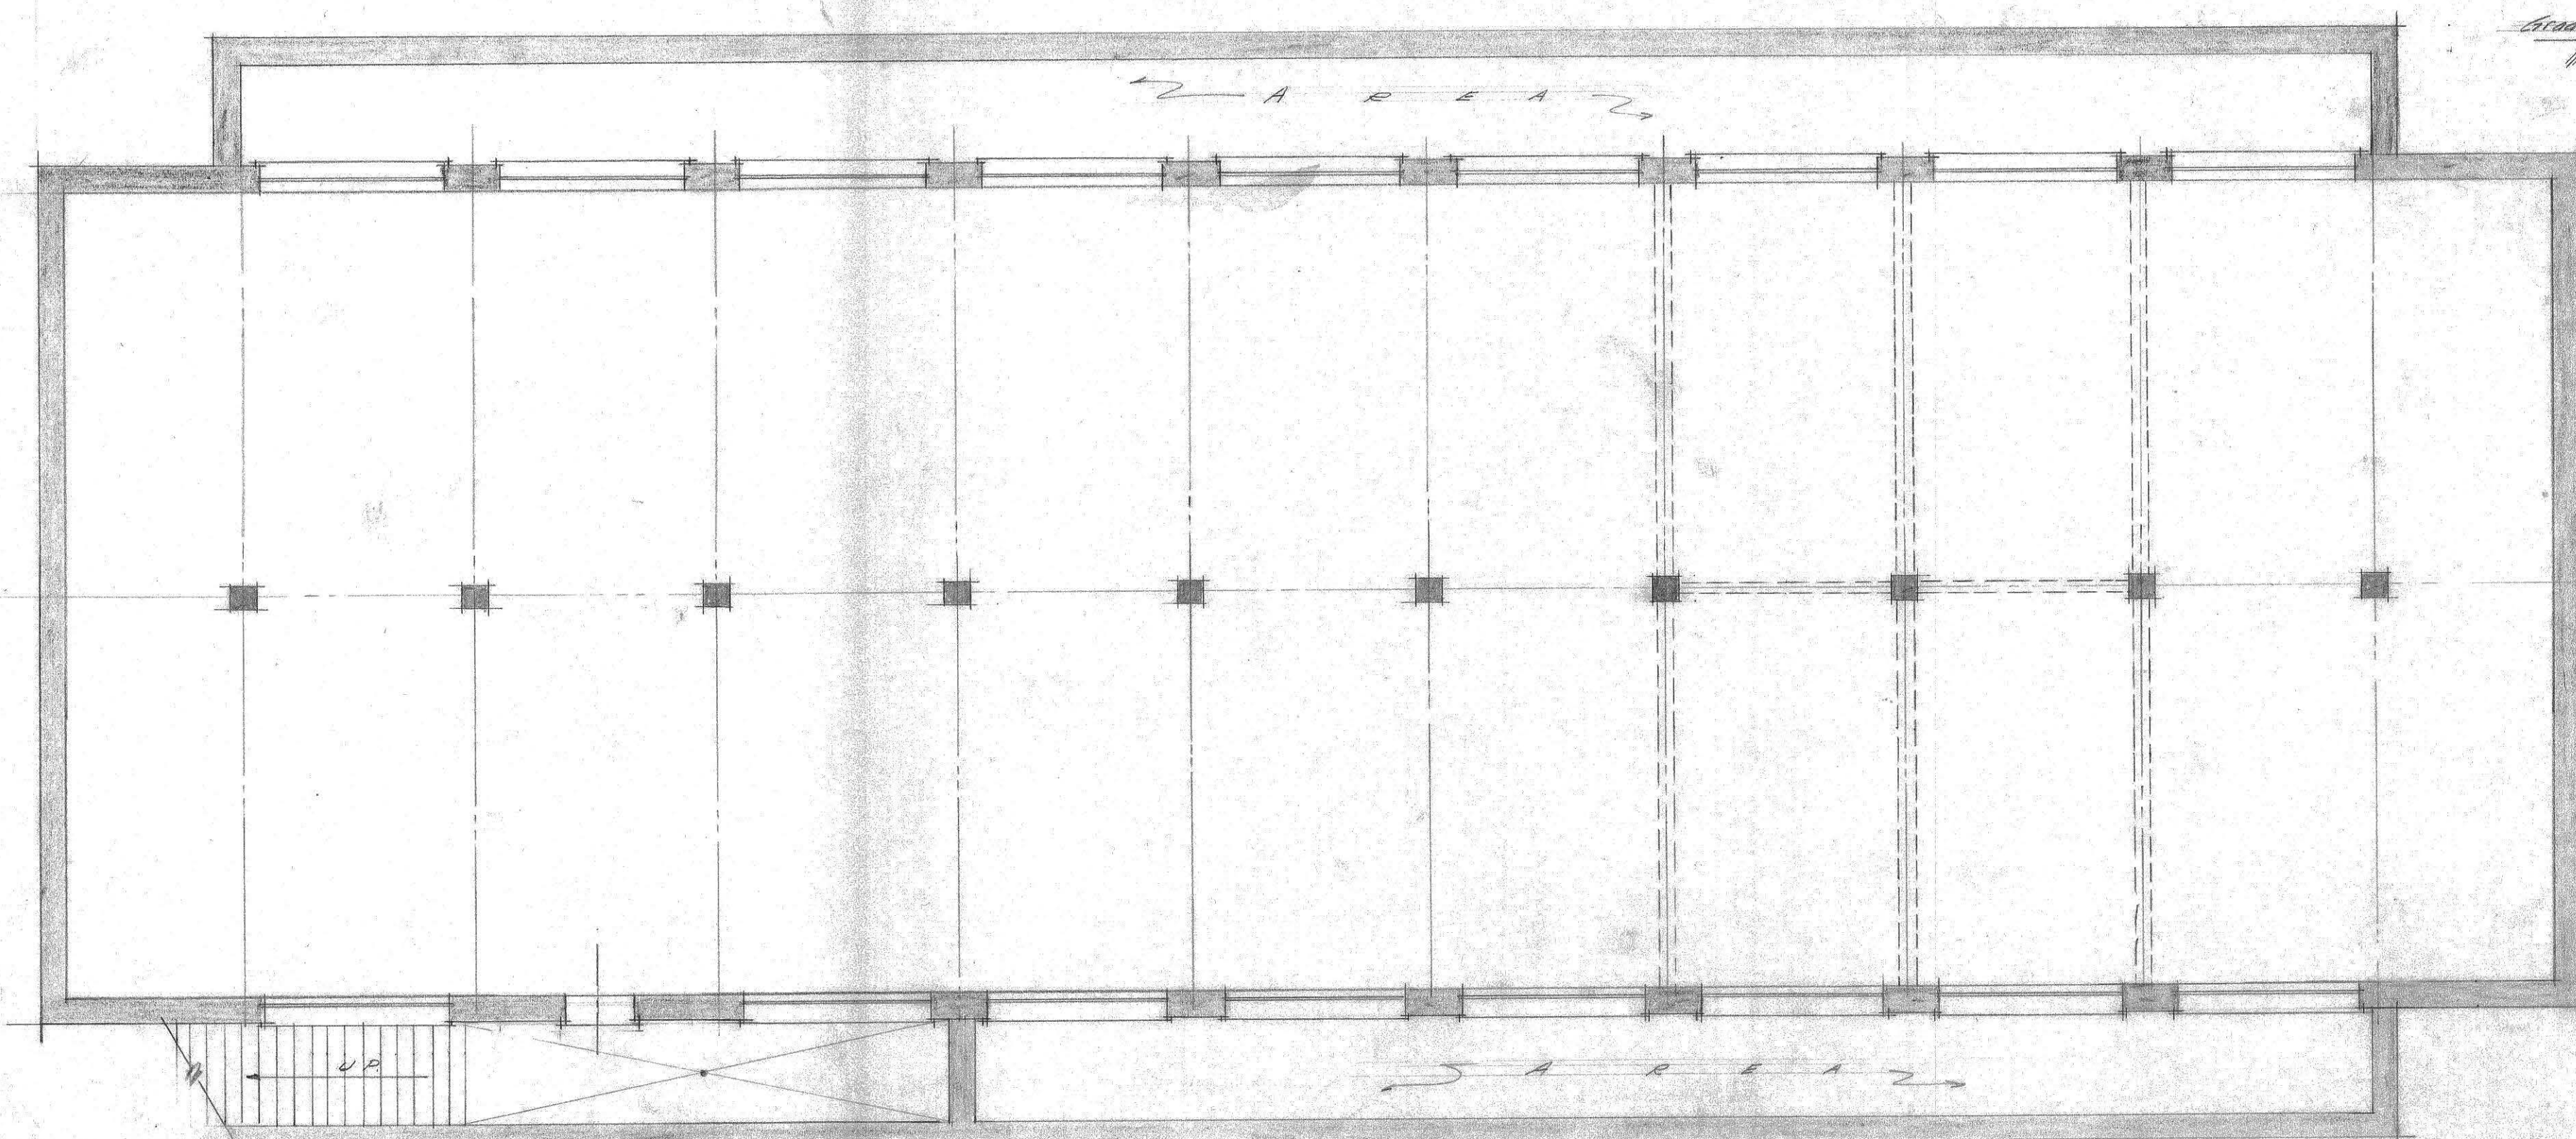

BASEMENT PLAN

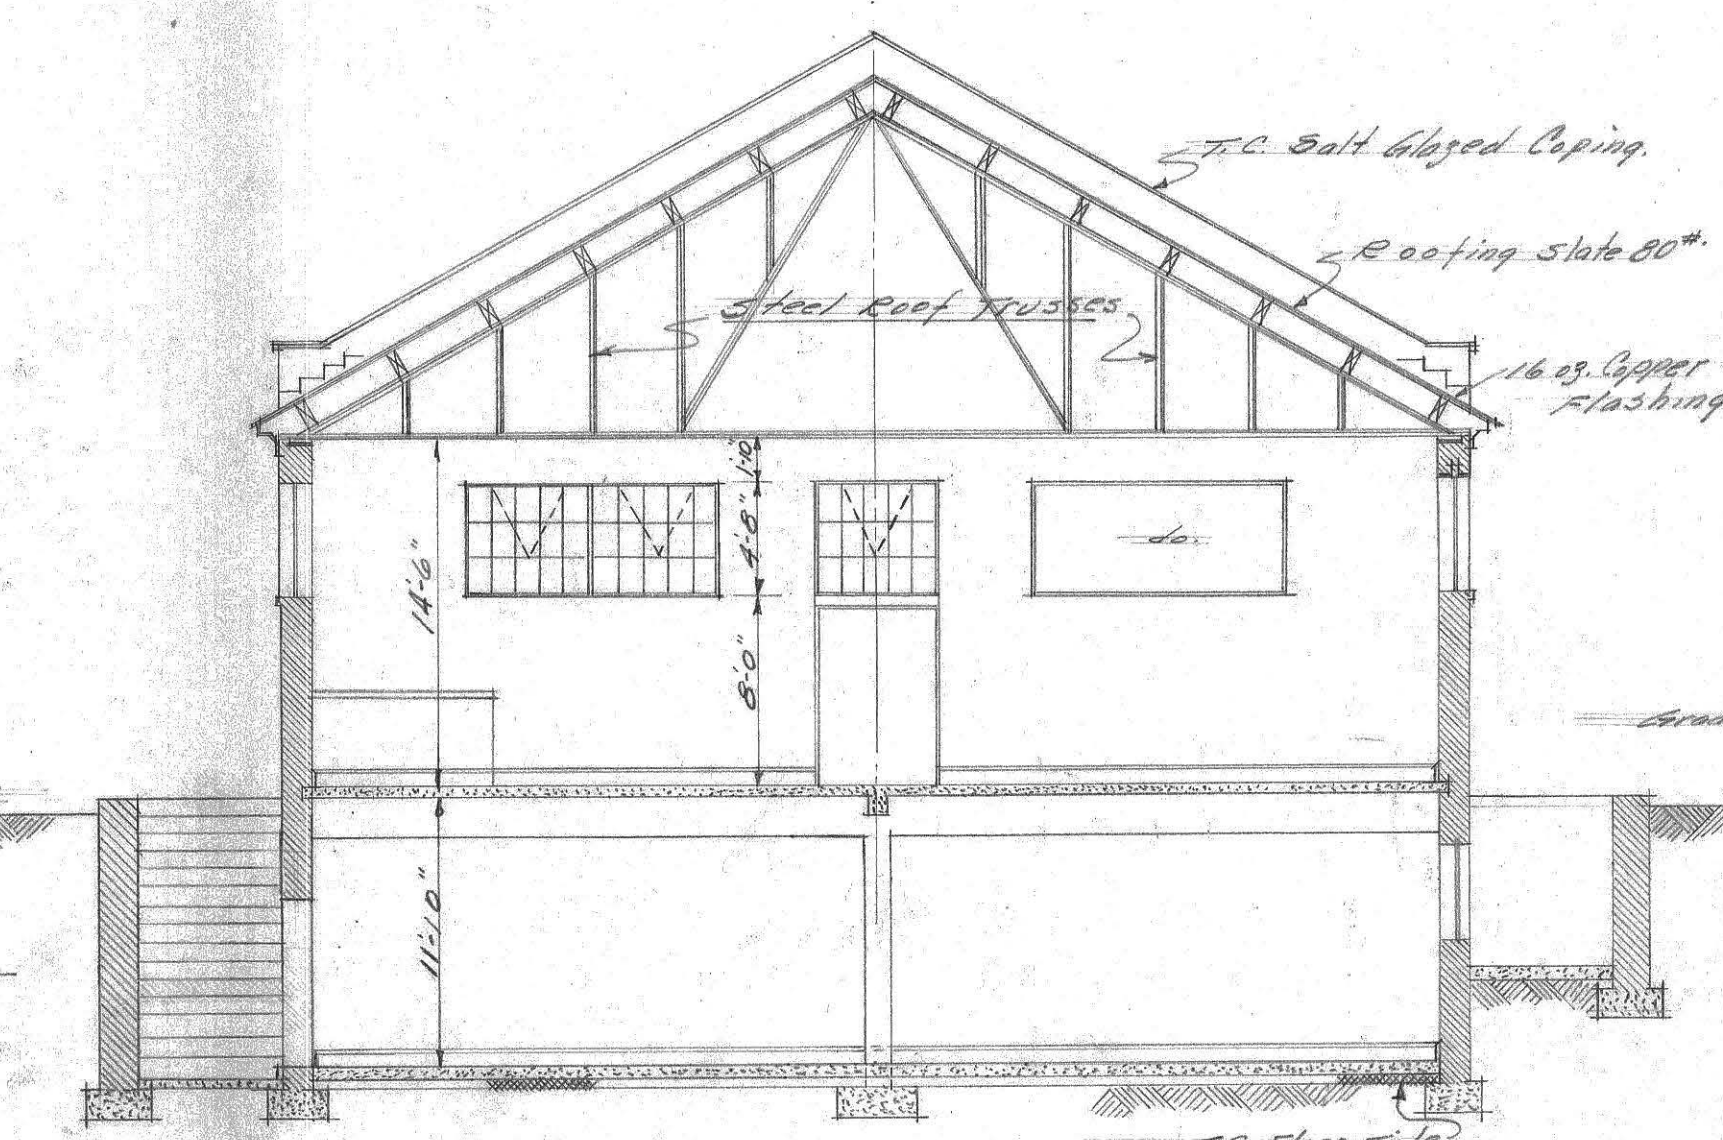

SECTION A-A

CONSTRUCTING ENGINEERS OFFICE			
D.C. PENAL INSTITUTIONS, LORTON, VA.			
- DORMITORY BLDG. -			
SCALE 1/8" = 1'-0"			
DRAWN	CHECKED	DATE	NO.
C. Stock		6-9-37	1

JZ-21